

# WORKING DRAWINGS

FOR

# PROPOSED DWELLING

AT

LOT 5127 HOWELL CRESCENT  
TRUGANINA VIC 3029

FOR

KULWINDER SINGH BRAR / ARWINDER KAUR BRAR

## DRAWING SCHEDULE : ON A3 PAGES

- PG 1 – TITLE / GENERAL NOTES
- PG 2 – GENERAL NOTES
- PG 3 – SITE / ROOF PLAN
- PG 4 – GROUND FLOOR PLAN
- PG 5 – ELEVATIONS
- PG 6 – ELEVATIONS
- PG 7 – SECTION / DETAILS
- PG 8 – DETAILS
- PG 9 – DETAILS
- PG 10 – DETAILS
- PG 11 – DETAILS
- PG 12 – DETAILS
- PG 13 – ELECTRICAL

BUILDER  
PARVINDER SINGH BATT  
EAGLE EYE CONSTURCTIONS  
130 HORSLEY ST THORNHILL PARK  
0413 111 596  
EAGLEEYECONSTRUCTIONS8@GMAIL.COM

## GENERAL NOTES

### INTELLECTUAL PROPERTY AND USE OF THIS DOCUMENT

- This document has been prepared for the exclusive use of the client of [insert] (the designer), for the purpose expressly notified to the designer. Any other person who uses or relies on these plans without the designer's written consent does so at their own risk and no responsibility is accepted by the designer for such use and/or reliance.
- This document is to be read in conjunction with all drawings, details and information provided by the consultants named herein, and with any other written instructions issued in the course of the contract.
- A building permit is required prior to the commencement of these works. The release of this document is conditional on the client obtaining the required building permit.

### MATERIALS AND TRADE PRACTICES

- All materials, construction and work practices shall comply with but not be limited to the current issue of [insert name of state/territory building regulations & year], National Construction Code 2022 Building Code Of Australia Vol. 2 (hereafter referred to as BCA), and all relevant current Australian Standards referred to therein.
- Work and site management practices shall comply with all relevant laws and by-laws.
- If any performance solution is proposed, it shall be assessed and approved by the [relevant building surveyor/building certifier] as meeting BCA performance requirements prior to implementation or installation.
- Installation of all services shall comply with the respective supply authority's requirements.

### VARIATIONS

- Should any conflict arise between these plans and BCA, Australian Standards or a manufacturer's instructions, this discrepancy shall be reported immediately to the designer, before any other action is taken.
- The client and/or the client's builder shall not modify or amend the plans without the knowledge and consent of the designer, except where the [relevant building surveyor/building certifier] makes minor necessary changes to facilitate the building permit application, and where such changes are reported back to the designer within 48 hours of their making.
- The approval by the designer of a substitute material, work practice or the like is not an authorisation for its use or a contract variation. Any variations and/or substitutions to materials or work practices shall be accepted by all parties to the building contract and, where applicable, the [relevant building surveyor/building certifier], prior to implementation.

### MEASUREMENTS

- Figured dimensions take precedence over scaled dimensions.
- Site plan measurements are in metres. All other measurements are in millimetres, unless noted otherwise.
- Unless noted otherwise, dimensions on floor plans, sections and external elevations represent timber frame and structural members, not finished linings/cladding.
- Window sizes are nominal only. Actual size may vary according to manufacturer.
- The builder and subcontractors shall check and verify all dimensions, setbacks, levels, specifications, and all other relevant documentation prior to the commencement of any works. Report all discrepancies to the designer for clarification.




DRAWING TITLE  
TITLE / GENERAL NOTES

© THIS PLAN, DESIGN OR IDEAS MAY NOT BE COPIED, LOANED OR BORROWED WITHOUT PRIOR CONSENT FROM PLANFORM.  
THIS DOCUMENT IS CONFIDENTIAL

PROJECT: PROPOSED DWELLING  
AT: 5127 HOWELL CRESCENT  
TRUGANINA VIC 3029  
FOR: KULWINDER SINGH BRAR / ARWINDER KAUR BRAR  
DRAWN: JT / EY  
DATE: 5.03.25  
SCALE: 1:100 (A3)  
JOB NO: 10172025  
STATUS: WORKING DWG  
PG NO: 01

REV	DATE	AMENDMENT
–	18.02	CONCEPT

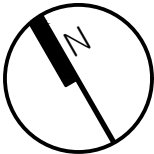

E | INFO@PLANFORM.COM.AU  
PH | 0431 020 698  
MAIL | PO BOX 576, SOUTH MORANG, VIC, 3752.  
WEB | WWW.PLANFORM.COM.AU

5B / 2 MURDOCH ROAD SOUTH MORANG  
SOUTH MORANG CORPORATE CENTRE



SUPPLEMENTARY NOTES

SITE PROTECTION DURING THE CONSTRUCTION PERIOD

- Protective outriggers, fences, awnings, hoarding, barricades and the like shall be installed where necessary to guard against danger to life or property or when required by the relevant building surveyor and/or council.
- Where required by council, the builder shall construct a temporary crossing placed over the footpath.
- All practicable measures shall be implemented to minimise waste to landfill. The builder may use a construction waste recovery service, or sort and transport recyclable materials to the appropriate registered recycler. Materials shall not be burned on site.
- A site management plan shall be implemented from the commencement of works, to control sediment run-off in accordance with [insert relevant state/council guidelines or regulation]. Silt fences shall be provided to the low side of the allotment and around all soil stockpiles and storm water inlet pits/sumps and 'silt stop' filter bags or equivalent shall be placed over all storm water entry pits. Erosion control fabric shall be placed over garden beds to prevent surface erosion.
- Dust-creating material shall be kept sprayed with water so as to prevent any nuisance from dust.
- Waste materials shall not be placed in any street, road or right of way.
- Earthworks (unretained) shall not exceed 2m.
- Cut and fill batters shall comply with BCA Table 3.2.1.

PROTECTION OF THE BUILDING FABRIC

- The builder shall take all steps necessary to ensure the stability and general water tightness of all new and/or existing structures during all works.
- Windows, doors and service penetrations shall be flashed all around.
- All pliable membranes shall be installed to comply and be in accordance with BCA 10.8.1
- Gutters and drainage shall be supplied and installed in accordance with AS3500.3.
- Anti-ponding devices/boards shall be installed according to BCA 7.3.5.
- Dampcourses with weepholes and cavity flashings shall be installed in accordance with AS4773.2.
- Surfaces around the perimeter of a residential slab shall fall away from that slab by not less than 50mm over the first 1m. Where not stipulated in the geotechnical report, freeboard shall be not less than 50mm from an impermeable surface or 150mm from a permeable surface.
- Subfloor vents shall be located >600mm from corners and be installed below bearers. Such vents shall provide a rate per 1000mm run of external or internal cross walls of:

7,500mm<sup>2</sup> clear ventilation where particle board flooring is used; or

6,000mm<sup>2</sup> for other subfloor types.
- [Where a building other than detached class 10 is located in a termite-prone area] the building shall be provided with a termite management system compliant with AS3660.1 or AS3660.2.
- In saline or industrial environments, masonry units, mortar, and all built-in components shall comply with the durability requirements of Table 4.1 of AS4773.1, Part 1: Design.
- Building tie-downs shall be appropriate for the site wind classification and provided in accordance with BCA 5.6.6.
- Corrosion protection shall be suited to the site context and provided for built-in structural steel members such as steel lintels, shelf angles, connectors, accessories (other than wall ties) in accordance with Table 4.1 of AS4773.1 Masonry in Small Buildings, Part 1: Design.
- Sheet roofing shall be protected from corrosion in a manner appropriate to the site context, in accordance with BCA Table 7.2.2a.
- Single leaf masonry walls shall be weatherproofed per BCA 5.7.6.
- [In climate zones 6, 7 and 8] Unless excluded by BCA 10.8.3(2) roofs shall be provided with ventilation openings per BCA 10.8.3.
- External waterproofing for on flat roofs, roof terraces, balconies and terraces and other similar horizontal surfaces located above internal spaces of a building shall comply with BCA H2D8.
- Waterproofing of wet areas - being bathrooms, showers, shower rooms, laundries, sanitary compartments and the like - shall be provided in accordance with BCA 10.2.
- Balcony waterproofing shall be installed in accordance with AS4654.1 & AS4654.2.

GLAZING

- Glazed units shall be installed in accordance with BCA 8.3.2.
- Fully framed glazing installed in the perimeter of buildings shall comply with BCA 8.3.3.
- Glass - including, but not limited to, windows, doors, screens, panels, splashbacks and barriers - shall comply with BCA 3.3.3.
- Glazing subject to human impact shall comply with BCA 8.4.

FOOTINGS

- Footings shall not, under any circumstance, encroach over title boundaries or easement lines.
- Where concrete stumps are to be used, these shall be:

100 x 100mm (1x 5mm HD wire) if up to 1400mm long

100 x 100mm (2x 5mm HD wires) if 1401mm to 1800mm long

125 x 125mm (2x 5mm HD wires) if 1801mm to 3000mm long.
- 100mm x 100mm stumps that exceed 1200mm above ground level shall be braced where no perimeter base brickwork is provided.
- All concrete footings shall be founded at a depth to a minimum required bearing capacity and/or in accordance with recommendations contained in soil report (or otherwise at engineer's discretion).

STORMWATER AND SEWERS

- 100 mm dia. Class 6 UPVC stormwater line min grade 1:100 shall be connected to the legal point of discharge to the relevant authority's approval. Provide inspection openings at 9m centres and at each change of direction.
- Covers to underground stormwater drains shall be not less than:

100mm under soil

50mm under paved or concrete areas

100mm under unreinforced concrete or paved driveways

75mm under reinforced concrete driveways
- The builder and subcontractor shall ensure that all stormwater drains, sewer pipes and the like are located at a sufficient distance from any buildings, footing and/or slab edge beams so as to prevent general moisture penetration, dampness, weakening and undermining of any building and its footing system.

SAFETY OF BUILDING USERS

- Where stairs, ramps and balustrades are to be constructed, these shall comply with all provisions of BCA 11.2.
- Other than spiral stairs:

Risers shall be 190mm max and 115mm min

Goings shall be 355mm max and 240mm min

2r+g shall be 700mm max and 550mm min

There shall be less than 125mm gap between open treads.
- All treads, landings and the like shall have a slip resistance classification of P3 or R10 for dry surface conditions and P4 or R11 for wet surface conditions, or a nosing strip with a slip-resistance classification of P3 for dry surface conditions and P4 for wet surface conditions.
- Barriers shall be provided where it is possible to fall 1m or more from the level of the trafficable surface to the surface beneath. Such barriers (other than tensioned wire barriers) shall be:

1000mm min above finished stair level (FSL) of balconies, landings etc; and

865mm min above FSL of stair nosing or ramp; and

vertical, with gaps of no more than 125mm.
- Where the floor below a bedroom window is 2m or more above the surface beneath, the window shall comply with BCA Clause 11.3.7.
- Where the floor below a window other than in a bedroom is 4m or more above the surface beneath, the window shall comply with BCA Clause 11.3.8.
- Where a bedroom window is 2m or more above the surface beneath, or it is possible to fall 4m or more from the level of any trafficable surface to the surface beneath, any horizontal element within a barrier between 150mm and 760mm above the floor shall not facilitate climbing.
- Handrails shall be continuous, with tops set >865mm vertically above stair nosing and floor surface of ramps.
- Wire barriers shall comply with BCA 11.3.4 and 11.3.6.
- A glass barrier or window serving as a barrier shall comply with BCA H1D8.
- Class 1 buildings with air permeability of not more than 5 m<sup>3</sup>/hr.m<sup>2</sup> at 50 Pa shall be provided with a mechanical ventilation system complying with H6V3.Inward-opening swing doors to fully enclosed sanitary compartments shall comply with BCA Clause 10.4.2.
- All shower walls and walls adjacent to toilet shall be braced with 12mm ply for future grab rails or supply noggings with a thickness of at least 25mm in accordance with recommendations of Liveable Housing Design Guidelines.
- Flooring in wet areas, laundry and kitchen shall be slip resistant.
- Door hardware shall be installed 900mm - 1100mm above the finished floor.
- There shall be a level transition between abutting internal surfaces (a maximum vertical tolerance of 5mm between abutting surfaces is allowable provided the lip is rounded or bevelled).

SERVICES

- Solar collector panel locations are indicative only. Location and size are dependent on manufacturer's/installer's recommendation.
- Ductwork for heating and cooling systems shall comply with AS4254 & AS/NZS 4859.1 in accordance with climate zone requirements set down in BCA Table 3.

TIMBER FRAMING

- Standard timber roofing and wall framing shall be provided in accordance with AS1684 (Residential Timber-Framed Construction) and all relevant supplements.

ELECTRICAL

- Smoke detectors shall be fitted where none are present, or where existing are non-compliant with AS3786.
- New smoke detectors shall be interconnected; mains-powered; and located and installed per BCA 9.5.2 and 9.5.4.
- In a Class 10a private garage, an alternative alarm may be installed per BCA 9.5.1(b).
- Light switches shall be positioned in a consistent location 900mm - 1100mm above the finished floor level; horizontally aligned with the door handle at the entrance to a room.
- Power points shall not be installed lower than 300mm above finished floor level.
- All electrical penetrations shall be sealed using material appropriate to the rating of the cable and/or device.
- Only stamped IC4-rated downlights shall be installed and insulation shall not be penetrated for downlights.
- Ductwork for exhaust fans and heating and cooling systems shall comply with AS4254 & AS/NZS 4859.1 in accordance with climate zone requirements set down in BCA 13.7.4.
- Exhaust from a bathroom, sanitary compartment or laundry shall be discharged directly via an insulated shaft or R1 insulated ducting to outdoor air. Minimum flow rates shall be:

40 l/s for kitchen & laundry

25 l/s for bathroom or sanitary compartment.
- An exhaust system that is not run continuously and is serving a bathroom or sanitary compartment that is not ventilated in accordance with BCA 10.6.2(a) shall be interlocked with the room's light switch; and include a 10 minute run-on timer.
- Exhaust fans, rangehoods and the like shall be installed with self-closing dampers.

SPECIFICATIONS

SUB FLOOR

- Refer to engineers drawings and computations.

FLOORING

- Floor finishes as selected by client.

WALL FRAMING

- Framing must be in accordance with as.1684.
- Bottom plate 90x45 mgp10
- Studs 90x45 mgp10 at 450 ctrs
- Jamb studs 2 / 90x45 mgp10 pine
- Noggins 70x35 merch at 1350 ctrs max
- Top plate 2 / 90x45 mgp10 pine
- Lintels to engineers design and specification.
- All exposed timber to be h3 treated pine.

ROOF FRAMING

- Roof trusses as per manufacturers design and specifications. manufacturers computations are to be provided prior to frame inspection. Builder to confirm eaves do not clash with windows or molds prior to ordering trusses.

- Roof battens: 38x75 f8 hw at 330 ctrs (tile)

38x75 f8 hw at 900 ctrs (colorbond)

38x75 f8 hw at 900 ctrs (klip-lok)

ROOFING TYPE:

- Selected colorbond roof at 22.5°

EXTERNAL FINISHES

- All materials and finishes to clients specification.
- Brickwork
- Brickwork with render finish

INTERNAL WALL FINISHES

- 10mm plasterboard to be painted (all internal walls)
- 10mm plasterboard to be painted (all internal ceilings)
- Client to select square finish or cornice for each room.

WET AREAS

- All wet areas to have impervious finish to floor and walls (tiles) in accordance with the NCC 2022 and AS.3740.2004.
  - Showers to 2100a.f.l min
  - sinks, troughs and hand basins – 300mm min
- All waterproof as per as 3740 and NCC 2022 part 10.2

BUILDING THERMAL PERFORMANCE


- Works shall be constructed in accordance with the stamped plans endorsed by xxx, accredited thermal performance assessor DMNXXX, without alteration.
- The NatHERS energy rating contains inbuilt assumptions about the integrity of the building fabric with regards insulation, draughtproofing and glazing. Works shall comply with the following measures, to ensure that the as-built performance corresponds to that modelled in the energy rating.
- Insulation as follows shall be installed in accordance with BCA 13.2.2:

External walls	R[insert value]
Roof	R[insert value]
Ceiling	R[insert value]
Under floor	R[insert value]
Under slab	R[insert value]
Side slab	R[insert value]
- Insulation shall be installed tight and continuous, without gaps and cracks, hard up against internal linings (including subfloor). There shall be no air gap between an internal lining and insulation. Junctions between internal and external walls shall be insulated.
- Insulation shall not be crushed or compressed.
- Box gutters and manhole covers shall be insulated to the same R-value as the roof, using insulation batts or blanket or closed-cell foam.
- Downlights shall be stamped as IC4 rated, airtight and covered by insulation.
- [in climate zones 6, 7 and 8] a vapour permeable layer shall be installed per manufacturer's instructions in all new external walls. The material shall be overlapped and fully taped on the external side to ensure a tight seal. All penetrations in the membrane shall be sealed, ensuring that the material covers gaps between studs and doors and window frames. Any flashing around windows shall be taped over the building wrap.
- Where a foil-backed membrane is used, timber battens shall be used to minimise thermal conduction.
- All trades shall be instructed to replace any insulation they have removed in the course of their work and to tape any cuts/penetrations in building wrap. All penetrations shall be caulked using a fit-for-purpose flexible sealant.
- All redundant openings such as decommissioned chimneys and wall vents shall be sealed off at top and bottom, unless an unflued gas heater is present.
- Caulking products shall be appropriate for the intended application.
- Before installing mouldings, a fit-for-purpose, long-lasting proprietary tape or flexible caulking product shall be used to seal junctions of:

Plasterboard and floor
Plasterboard and top plate (for square set cornices)
Vertical and horizontal plasterboard
Tops, bottoms and sides of architraves and plasterboard.
All exhaust fans and ducts, including rangehoods, shall be fitted with self-closing mechanisms.
- Where it is not possible to insulate under an existing timber floor, gaps between floorboards shall be sealed before applying finishes or coverings.
- External doors and windows shall be draughtproofed per BCA 13.4.4 using a durable, fit-for-purpose seal.
- Cavity slider pockets shall be sealed before installation, either by wrapping with vapour permeable membrane, or by screwing plaster securely to the frame and applying a silicon bead.
- Conditioned Class 1 and unconditioned Class 10a spaces shall be separated by insulation. Any openings between such spaces shall be weather-stripped.
- The client retains the right to implement a blower door test to test for air tightness prior to painting. Target air permeability is not more than [insert] m<sup>3</sup>/hr.m<sup>2</sup> at 50 Pa.
- Window sizes nominated are nominal. Actual size may vary minimally according to manufacturer; however, opening styles, overall size, U-value and SHGC values are inbuilt into the energy rating and may not be altered without the express approval of the project's energy rater.
- Glazed doors and windows shall be [insert] wind rated, double-glazed, weather-stripped and flashed all around.
- Openable windows shall be provided with flyscreens.

WHOLE A HOMES SCHEDULE

APPLIANCE TYPE	SPECIFICATIONS
HEATING	12KW Reverses Cycle
COOLING	12KW Reverses Cycle
LIGHTING	3W/M2
HOT WATER SYSTEM	Instantaneous
COOKING	GAS
APPLIANCES	
COOKING	ELECTRIC
APPLIANCES	
SOLAR SYSTEM	3KW solar system
BATTERY TYPE	N/A
BATTERY CAPACITY	N/A
POOL	N/A
POOL PUMP	N/A
POOL PUMP	N/A
EFFICIENCY	N/A
E   INFO@PLANFORM.COM.AU	
PH   0431 020 698	
MAIL   PO BOX 576, SOUTH MORANG, VIC, 3752.	
WEB   WWW.PLANFORM.COM.AU	
5B / 2 MURDOCH ROAD SOUTH MORANG	
SOUTH MORANG CORPORATE CENTRE	

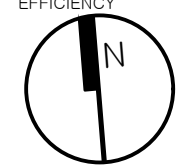

DRAWING TITLE

SUPPLEMENTARY / SCHEDULES

© THIS PLAN, DESIGN OR IDEAS MAY NOT BE COPIED, LOANED OR BORROWED WITHOUT PRIOR CONSENT FROM PLANFORM. THIS DOCUMENT IS CONFIDENTIAL

BUILDER  
PAVINDER SINGH BATHH  
EAGLE EYE CONSTRUCTIONS  
130 HORSLEY ST THORNHILL PARK  
0413 111 596  
EAGLEEYECONSTRUCTIONS8@gmail.com















PROJECT:  
PROPOSED DWELLING  
AT:  
5127 HOWELL CRESCENT  
TRUGANINA VIC 3029  
FOR:

DRAWN: JT / EY  
DATE: 5.03.25  
SCALE: 1:100 (A3)  
JOB NO: 10172025  
STATUS: WORKING DWG  
PG NO: 02

REV	DATE	AMENDMENT
–	18.02	CONCEPT

SITE & AREA ANALYSIS		
	M2	%
SITE (APPROX)	514	
SITE COVERAGE	308.42	60.00
PERMEABILITY	169.98	33.07
GARDEN AREA	166.48	32.39
PROPOSED DWELLING		
	AREA	SG
GROUND FLOOR	247.94	26.69
GARAGE	41.19	4.43
PORCH	7.15	0.77
ALFRESCO	12.14	1.31
TOTAL AREA	308.42	33.20

## LEGEND

- DP  100 x 50mm SELECTED COLORBOND DOWNPIPE
- RWH  100 x 50mm COLORBOND DOWNPIPE WITH SELECTED RAIN WATER HEAD
- CON.  CONCEALED DOWNPIPE WITHIN STRUCTURE
-  FLOOR WASTE
-  EXTERNAL TAP POINT
-  RECYCLED WATER TAP
-  GAS METER
-  WATER METER
- BG1  100MM DEEP X 400MM WIDE COLORBOND BOX GUTTER (ADJUST ON SITE TO SUITE)
-  DIRECTION OF ROOF FALL
-  MIN. 100 Ø mm U.P.V.C. SEWER DRAIN CLASS "SH" CONNECTED INTO LEGAL POINT OF DISCHARGE AS DIRECTED BY LOCAL AUTHORITY.
-  100mm PVC RISER PIPE CONNECTOR TO STORMWATER DISCHARGE PIPE
-  GRATED INLET PIT/SILT TRAP CONNECTED TO STORMWATER SYSTEM DIRECTED TO LEGAL POINT OF DISCHARGE
-  PROVIDE AGRICULTURAL DRAIN OR SIMILAR AT BASE OF CUT GRADED TO SILT TRAP AT 1:00 MIN. DRAINS SHALL BE PROTECTED BY GRAVEL FILTERS.

**DRAINAGE NOTES:**  
ALL SURFACE DRAINAGE WORKS SHALL BE INSTALLED IN ACCORDANCE WITH THE ENGINEERS DESIGN DETAIL FOR THE SELECTED FOOTING SYSTEM AND SOIL CLASSIFICATION AND IN ACCORDANCE WITH CLAUSE 5.6.3 DRAINAGE REQUIREMENTS OF AS2870-2011, WHEREIN FOR BUILDINGS ON MODERATELY, HIGHLY AND REACTIVE SITES:


- SURFACE DRAINAGE SHALL BE CONTROLLED THROUGHOUT CONSTRUCTION AND BE COMPLETED BY THE FINISH OF CONSTRUCTION.
- THE BASE OF TRENCHES SHALL SLOPE AWAY FROM THE BUILDING.
- WHERE PIPES PASS UNDER THE FOOTING SYSTEMS, CLAY PLUGS ARE ADOPTED TO PREVENT THE INGRESS OF WATER.

FOR BUILDINGS ON HIGHLY AND REACTIVE SITES, THE DRAINER SHALL PROVIDE DRAINAGE ARTICULATION TO ALL STORMWATER, SANITARY PLUMBING DRAINS AND DISCHARGE PIPES IN ACCORDANCE WITH CLAUSE 5.6.4 PLUMBING REQUIREMENTS, WHEREIN FLEXIBLE JOINTS IMMEDIATELY OUTSIDE THE FOOTING AND COMMENCING WITHIN 1M OF THE BUILDING PERIMETER ARE REQUIRED TO ACCOMMODATE THE REQUIRED DIFFERENTIAL MOVEMENT BASED ON THE SOIL CLASSIFICATION.

SURFACE WATER MUST BE DIVERTED AWAY FROM THE DWELLING AND GRADED AWAY FROM ALL FOUNDATIONS TO GIVE A SLOPE OF NOT LESS THAN 50MM OVER THE FIRST 1000MM FROM THE DWELLING

SUBSURFACE DRAINS TO REMOVE GROUND OR TABLE WATER SHALL BE DETAILED BY THE DESIGN ENGINEER. FURTHERMORE, DAMP-PROOFING MEMBRANE IN ACCORDANCE WITH NCC 2022 PART 3.3 ABCB SHALL BE INSTALLED FOR GROUNDWATER OR AGGRESSIVE SOILS

SITE CUT AND FILL TO BE MINIMUM OF 1.2M FROM DWELLING BOUNDARY AND BATTERED AT NO MORE THAN 45° SITE CUTS/FILLING WORKS NOT TO SUPPORTED BY RETAINING WALLS SHALL BE FINISHED WITH A BATTER OF A 45° AND AN AGRICULTURAL DRAIN AT THE BASE OF A SPOON DRAIN AT THE END OF ANY FUTURE PAVING.

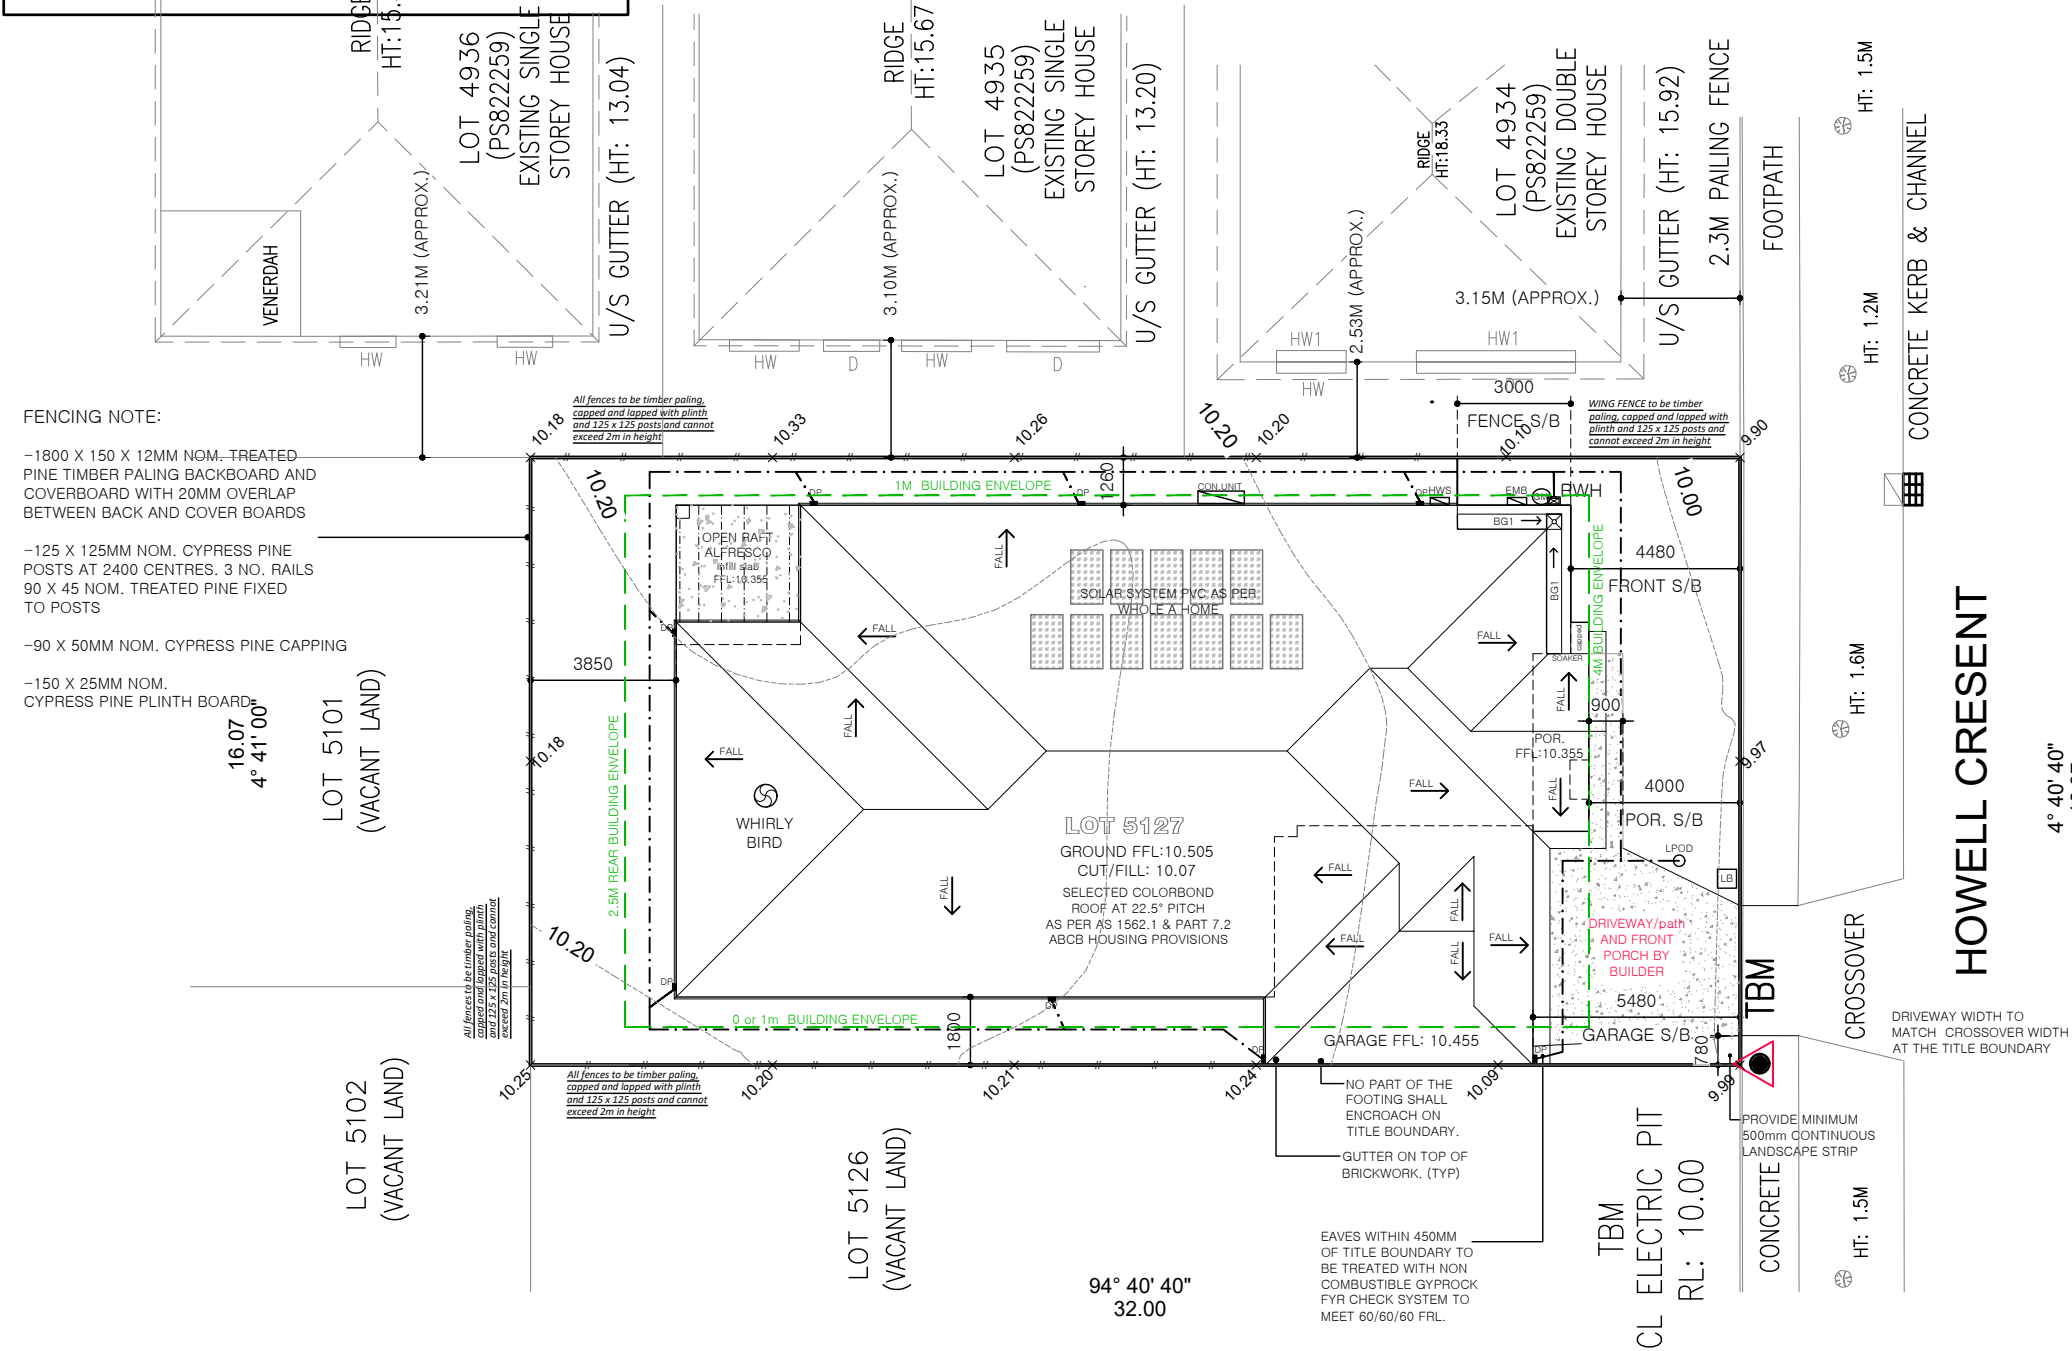

NOTE:

- DWELLING TO BE CONNECTED TO ESTATE RECYCLED WATER SYSTEM FOR USE IN TOILET FLUSHING AND GARDEN WATERING.
- THE BUILDER MUST COMPLETE ALL FIBRE CABLE ENTRY WORK IN ACCORDANCE WITH OPTICOMM GUIDELINES
- NO RETAINING WALLS TO BE VISIBLE TO THE STREET.
- TELEVISION ANTENNAS MUST BE LOCATED WITHIN THE HOUSE ROOF.

NOTE: ALL GLAZING TO COMPLY WITH AS 1288-2006 & AS2047

- PROVIDE SAFETY GLASS TO POWDER COATED ALUMINIUM FRAMED SLIDING DOOR COMBINATIONS TO COMPLY TO A.S. 1288-2006. (TYP)

## DRAWING TITLE

# SITE/ROOF PLAN


© THIS PLAN, DESIGN OR IDEAS MAY NOT BE COPIED, LOANED OR BORROWED WITHOUT PRIOR CONSENT FROM PLANFORM. THIS DOCUMENT IS CONFIDENTIAL

**BUILDER**  
PARVINDER SINGH BATH  
EAGLE EYE CONSTRUCTION  
130 HORSLEY ST THORNHILL PARK  
0413 111 596  
EAGLEEYECONSTRUCTIONS8@GMAIL.COM KULMINDER SINGH BRAR / ARWINDER KAUR BRAR

**PROJECT:**  
PROPOSED DWELLING  
AT:  
5127 HOWELL CRESCENT  
TRUGANINA VIC 3029  
FOR:

**DRAWN:** JT / EY  
**DATE:** 5.03.25  
**SCALE:** 1:200 (A3)  
**JOB NO:** 10172025  
**STATUS:** WORKING DWG  
**PG NO:** 03

REV	DATE	AMENDMENT
-	18.02	CONCEPT

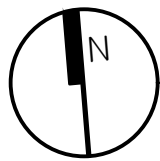

E | INFO@PLANFORM.COM.AU  
PH | 0431 020 698  
MAIL | PO BOX 576, SOUTH MORANG, VIC, 3752.  
WEB | WWW.PLANFORM.COM.AU

5B / 2 MURDOCH ROAD SOUTH MORANG  
SOUTH MORANG CORPORATE CENTRE



WALL CONSTRUCTION


EXTERNAL WALL CONSTRUCTION

- 240 BRICK VENEER CONSTRUCTION (TYP)

INTERNAL WALL CONSTRUCTION

- 90MM X 45MM MGP10 TIMBER STUDS (TYP)

90

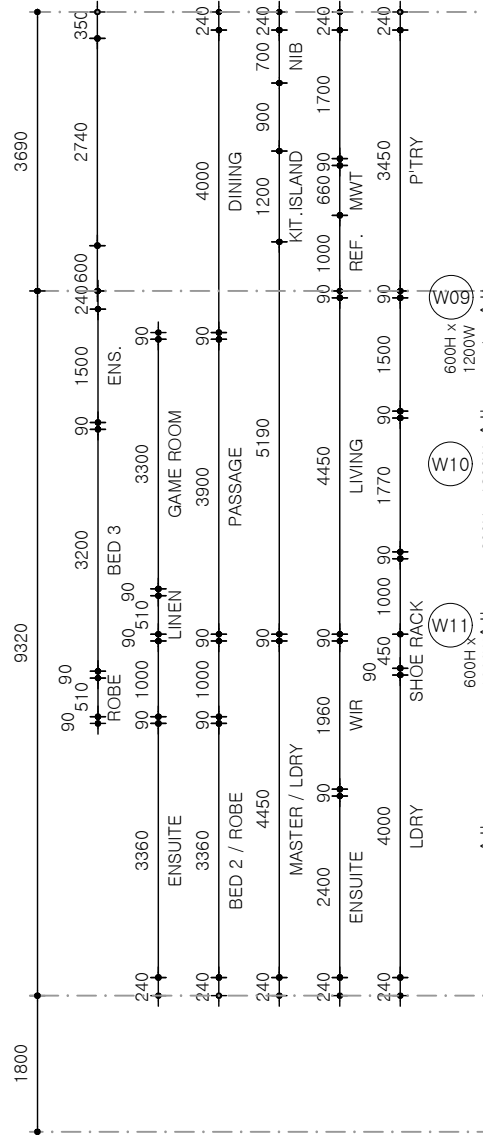

VENTILATION NOTES

VENTILATION OF ROOF SPACES TO BE IN ACCORDANCE WITH NCC 2022 VOLUME TWO ABCB PART 10.8.3

AN EXHAUST SYSTEM INSTALLED IN A KITCHEN, BATHROOM, SANITARY COMPARTMENT OR LAUNDRY MUST HAVE A MINIMUM FLOW RATE OF:  
A) 25L/s FOR BATHROOM OR SANITARY COMP; &  
B) 40L/s FOR A KITCHEN OR LAUNDRY.

FLOW RATE AND DISCHARGE OF EXHAUST SYSTEM – NCC 2022 ABCB PART 10.8.2

RANGEHOOD IS TO BE EXTERNALLY VENTED TO OUTSIDE AIR



DRAWING TITLE  
GROUND FLOOR


© THIS PLAN, DESIGN OR IDEAS MAY NOT BE COPIED, LOANED OR BORROWED WITHOUT PRIOR CONSENT FROM PLANFORM. THIS DOCUMENT IS CONFIDENTIAL

**BUILDER**  
PARVINDER SINGH BATH  
EAGLE EYE CONSTRUCTIONS  
130 HORSLEY ST THORNHILL PARK  
0413 111 596  
EAGLEEEYECONSTRUCTIONS80@GMAIL.COM

**PROJECT:**  
PROPOSED DWELLING  
**AT:**  
5127 HOWELL CRESCENT  
TRUGANINA VIC 3029  
**FOR:**

**DRAWN:** JT / EY  
**DATE:** 5.03.25  
**SCALE:** 1:100 (A3)  
**JOB NO:** 10172025  
**STATUS:** WORKING DWG  
**PG NO:** 04

REV	DATE	AMENDMENT
–	18.02	CONCEPT

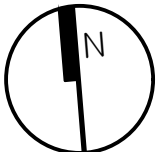

E | INFO@PLANFORM.COM.AU  
PH | 0431 020 698  
MAIL | PO BOX 576, SOUTH MORANG, VIC, 3752.  
WEB | WWW.PLANFORM.COM.AU

5B / 2 MURDOCH ROAD SOUTH MORANG  
SOUTH MORANG CORPORATE CENTRE



LEGEND

- SELECTED CONCRETE FINISH
- SELECTED WET AREAS (TILED)
- MH ROOF ACCESS HOLE
- SMOKE ALARM
- EXHAUST FAN
- AJ ARTICULATION JOINT
- PS PLUMBING STACK
- G CAPPED GAS POINT
- W CAPPED WATER POINT
- FLOOR WASTE
- TAP EXTERNAL TAP POINT
- GM GAS METER
- CHANGED CEILING

NOTES

- PERIMETER FLASHING AT FLOOR LEVEL OPENINGS IN WET AREA AS PER NCC 2022 PART 10.2 AND AS3740 – 2021.
- ALL GLAZING INCLUDING MIRRORS WITHIN 2000MM ABOVE THE FLOOR LEVEL IN BATHROOMS, ENSUITES, AND ROOMS OR ENCLOSURES CONTAINING SPAS SHALL BE GRADE A SAFETY GLASS OR GRADE B SAFETY GLASS IN ACCORDANCE WITH SECTION 5.8 OF AS 1288-2021.
- ALL WATERPROOFING TO BE IN ACCORDANCE WITH NCC 2022 PART 10.2 AND AS3740 – 2010.
- PROVIDE P4 (WET SURFACE) AND P3 (DRY SURFACE) CLASSIFICATION SLIP RESISTANCE TO LANDING EDGE STRIP, NOSING OR TREAD SURFACE IN ACCORDANCE WITH AS 4586.
- ALL SMOKE DETECTORS TO BE HARDWIRED AND INTERCONNECTED IN ACCORDANCE WITH NCC 2022 SMOKE ALARMS TO BE KEPT 300MM MIN. FROM WALLS, BULKHEADS, DOORWAYS ECT.
- WHERE DOOR THRESHOLD EXCEEDS 190mm ABOVE FINISHED GROUND LEVEL PROVIDE A LANDING, A MIN. WIDTH, THE WIDTH OF THE DOOR LEAF OPENING ONTO IT. STEPS:- RISER – 190 MAX.TREAD – 240 MIN.
- SELECTED FACE BRICKWORK WITH REFLECTIVE FOIL SARKING TO ALL EXTERNAL WALLS U.N.O. TO COMPLY WITH A.S. 3700 – 2018. VERTICAL ARTICULATION JOINTS TO CONFORM WITH NCC 2022 VOL 2 PART 5 ABCB. PROVIDE WALL TIES TO BRICKWORK AT MAXIMUM 600mm CTRS IN EACH DIRECTION AND WITHIN 300mm OF ARTICULATION JOINTS. (TYP.)

POWDER ROOM EXHAUST FAN NOTE  
i. EXHAUST FAN TO BE INTERLOCKED WITH ROOMS LIGHT SWITCH; AND  
ii. RUN-ON TIMER TO OPERATE FOR 10MIN AFTER THE LIGHT SWITCH IS TURNED OFF; AND  
iii. INDICATE SLIDING DOORS HAVE A 20MM UNDERCUT FOR 'MAKE-UP AIR'. to 700mm WIDE DOOR


THRESHOLD OF ALL INTERNAL DOORWAYS TO BE FLUSH

MATERIAL & COLOUR SCHEDULE

- 01


STACKED STONE

- MANUFACTURER: TILE FACTORY OUTLET
  - COLOUR: QUEBEC PASTEL
  - NATURAL STACK STONE 8777


- 02


RENDER FINISH

- MANUFACTURER:DULUX
  - COLOUR: WHITSUNDAY ISLAND


- 03


VERTICAL CLADDING

- MANUFACTURER: JAMES HARDIE SCYON AXON
  - COLOUR: MONUMENT


- 04


TIMBER

- MANUFACTURER:DULUX
  - COLOUR: MONUMENT


- 05


METAL SHEET ROOF

- MANUFACTURER: COLORBOND
  - COLOUR: WALLABY


- 06


WINDOW FRAMES

- COLOUR: BLACK


- 07


GUTTERS / FASCIAS / DOWN PIPES

- COLOUR: SURFMIST


- 08


GARAGE DOOR

- STEEL LINE - COLORBOND
  - Sectional Surfmist - SLIMLINE PROFILE


- 09


ELECTRICAL METER BOX

- METER BOX
  - COLOUR : WHITSUNDAY ISLAND - DULUX


- 10


DRIVEWAY/FRONT PORCH/PATH

- EXPOSED AGGREGATE
  - ECONOMIX - DAYTONA BEACH


- 11

FRONT DOOR

- FRONT DOOR - PAINTED
  - COLOUR : MONUMENT
  - CLEAR GLAZING INSERT




WHIRLY BIRD  
MANUFACTURER: COLORBOND  
COLOUR: WALLABY

ALL ARTICULATION JOINTS ARE TO BE CONTINUES ADJACENT TO OPENINGS

WEEPHOLES SHALL BE PROVIDED AT 1.2M CENTERS AND ABOVE OPENINGS GREATER THAN 1M

DAMP PROOF COURSE HEIGHTS  
i)150MM ABOVE EXTERNAL GROUND  
ii)75MM ABOVE EXTERNAL PAVED SURFACE


FACADE MATERIAL CALCULATOR		
MATERIAL	AREA	%
RENDER	11.75	55.53
STACKED STONE	6.31	29.82
TIMBER	3.10	14.65
TOTAL	21.16	100.00

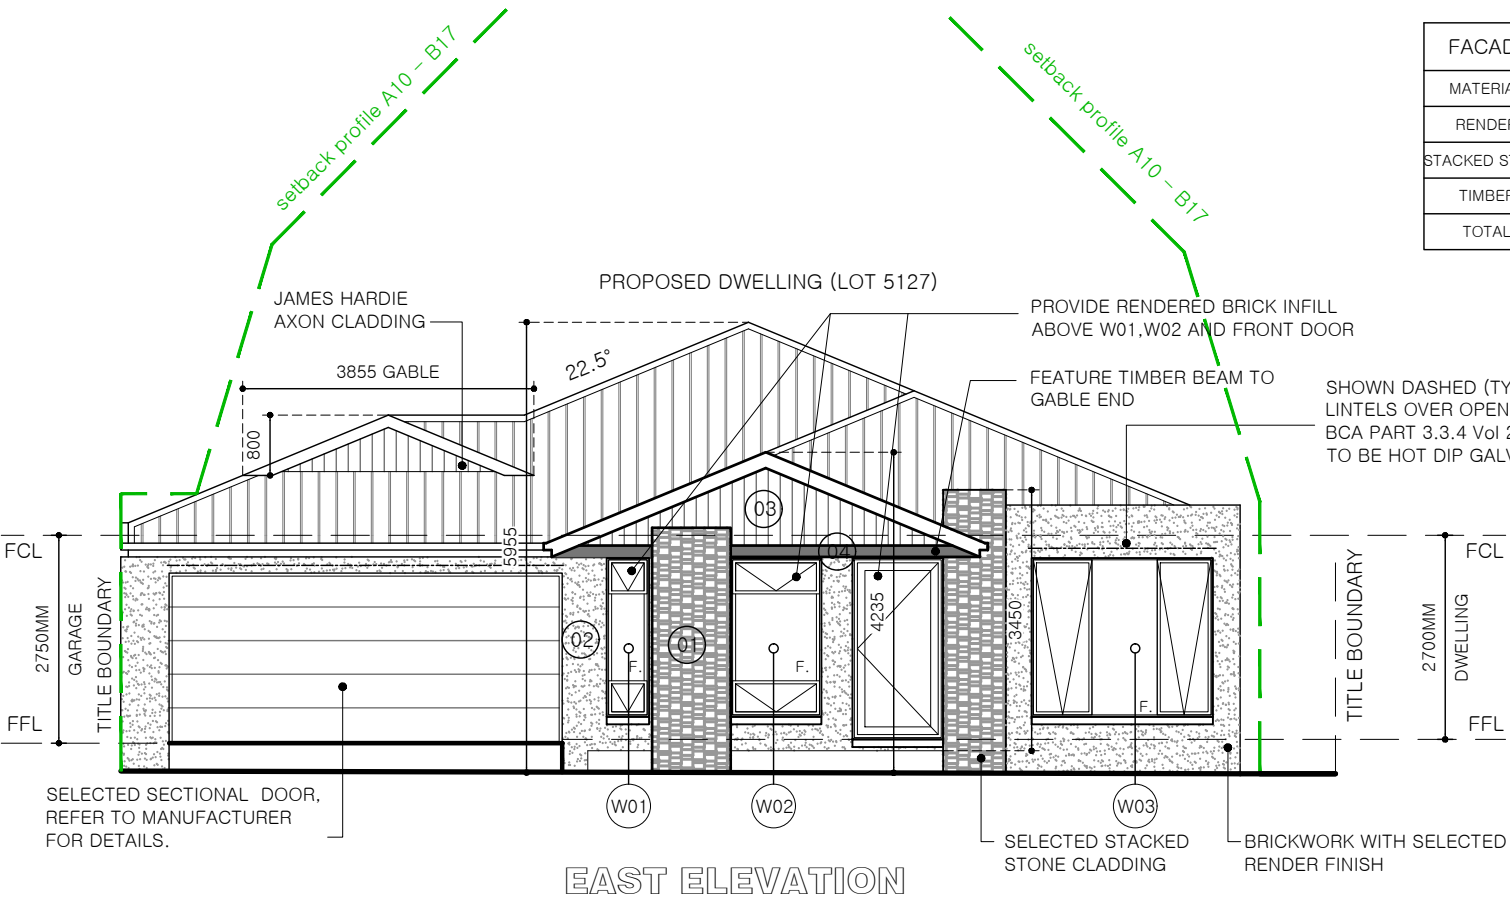

NOTE:  
NO LIGHT WEIGHT INFILL MATERIAL OVER WINDOWS, DOORS, OR GARAGE DOOR TO BE VISIBLE FROM PRIMARY AND SECONDARY FACADES.

TIMBER BEAMS TO PORCH AND PORTICOS TO BE HIDDEN INSIDE EAVES LINING.

RENDERED SURFACES ABOVE WINDOW OR DOOR OPENINGS MUST BE FLUSH WITH THE OUTSIDE FACE OF ADJOINING WALL.

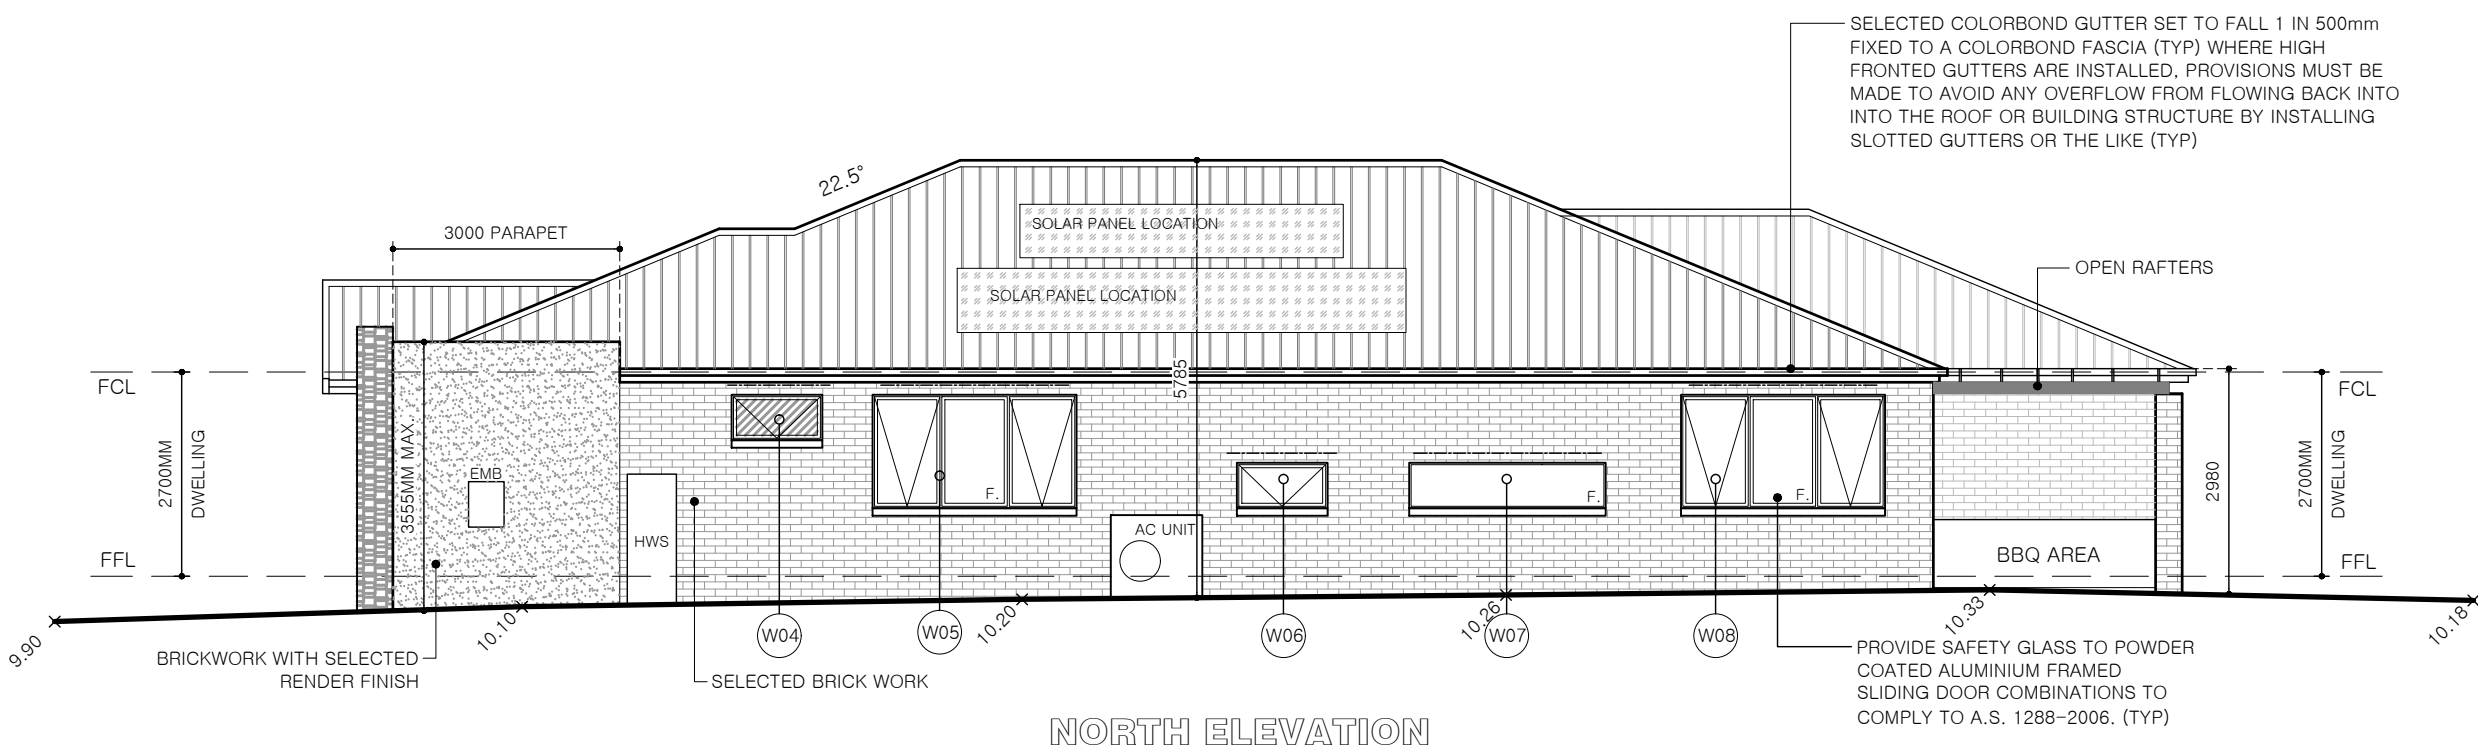

DRAWING TITLE  
ELEVATIONS

© THIS PLAN, DESIGN OR IDEAS MAY NOT BE COPIED, LOANED OR BORROWED WITHOUT PRIOR CONSENT FROM PLANFORM. THIS DOCUMENT IS CONFIDENTIAL


BUILDER  
PARVINDER SINGH BATH  
EAGLE EYE CONSTRUCTIONS  
130 HORSLEY ST THORNHILL PARK  
0413 111 596  
EAGLEEEYECONSTRUCTIONS80GMAIL.COM

PROJECT:  
PROPOSED DWELLING  
AT:  
5127 HOWELL CRESCENT  
TRUGANINA VIC 3029  
FOR:

KULWINDER SINGH BRAR / ARWINDER KAUR BRAR


DRAWN: JT / EY  
DATE: 5.03.25  
SCALE: 1:100 (A3)  
JOB NO: 10172025  
STATUS: WORKING DWG  
PG NO: 05

REV	DATE	AMENDMENT
-	18.02	CONCEPT

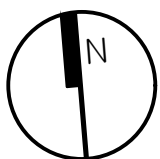

E | INFO@PLANFORM.COM.AU  
PH | 0431 020 698  
MAIL | PO BOX 576, SOUTH MORANG, VIC, 3752.  
WEB | WWW.PLANFORM.COM.AU

5B / 2 MURDOCH ROAD SOUTH MORANG  
SOUTH MORANG CORPORATE CENTRE

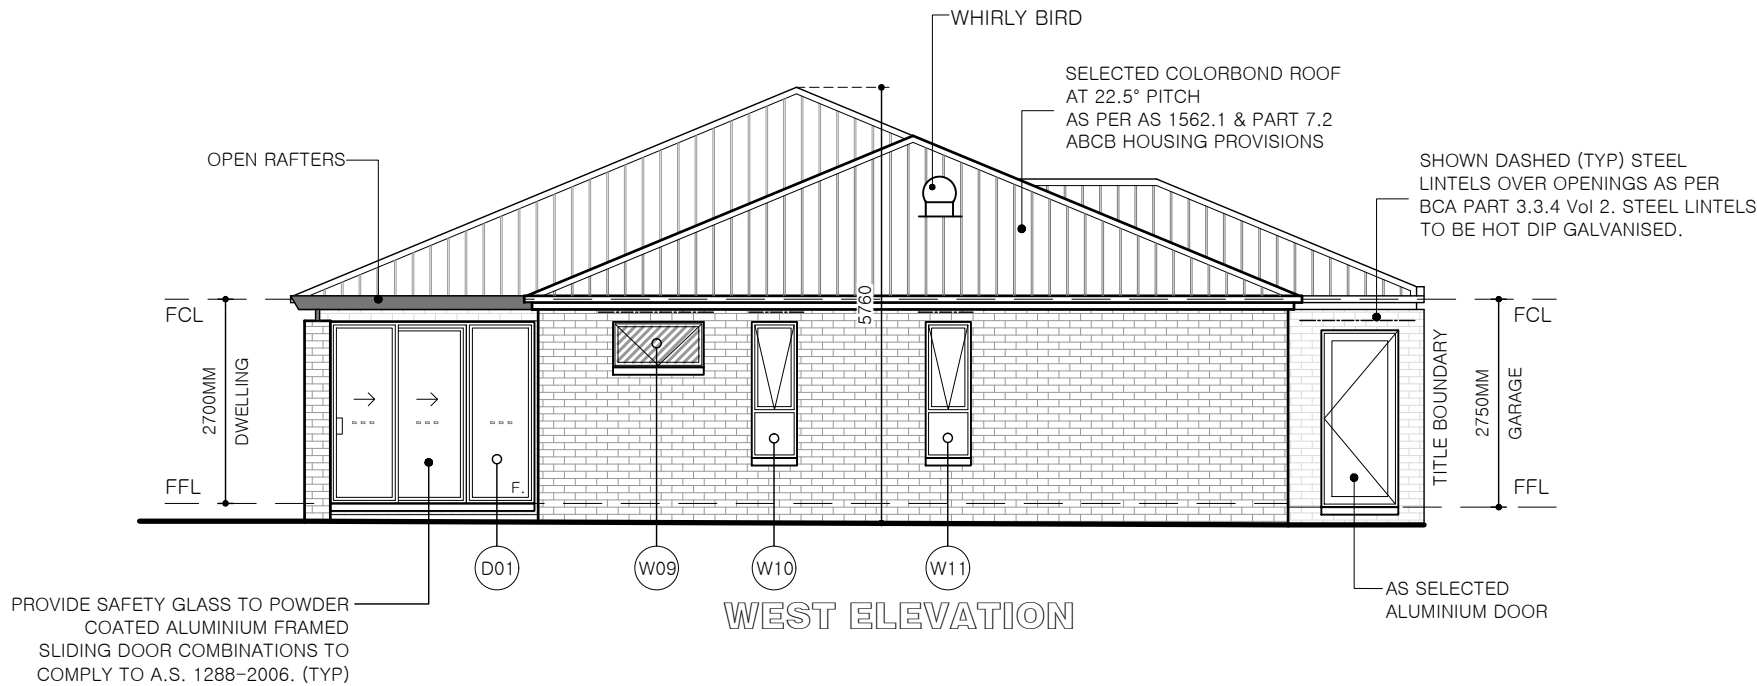


NOTE:

NO LIGHT WEIGHT INFILL MATERIAL OVER WINDOWS, DOORS, OR GARAGE DOOR TO BE VISIBLE FROM PRIMARY AND SECONDARY FACADES.

TIMBER BEAMS TO PORCH AND PORTICOS TO BE HIDDEN INSIDE EAVES LINING.

RENDERED SURFACES ABOVE WINDOW OR DOOR OPENINGS MUST BE FLUSH WITH THE OUTSIDE FACE OF ADJOINING WALL.

SELECTED COLORBOND GUTTER SET TO FALL 1 IN 500mm FIXED TO A COLORBOND FASCIA (TYP) WHERE HIGH FRONTED GUTTERS ARE INSTALLED, PROVISIONS MUST BE MADE TO AVOID ANY OVERFLOW FROM FLOWING BACK INTO THE ROOF OR BUILDING STRUCTURE BY INSTALLING SLOTTED GUTTERS OR THE LIKE (TYP)

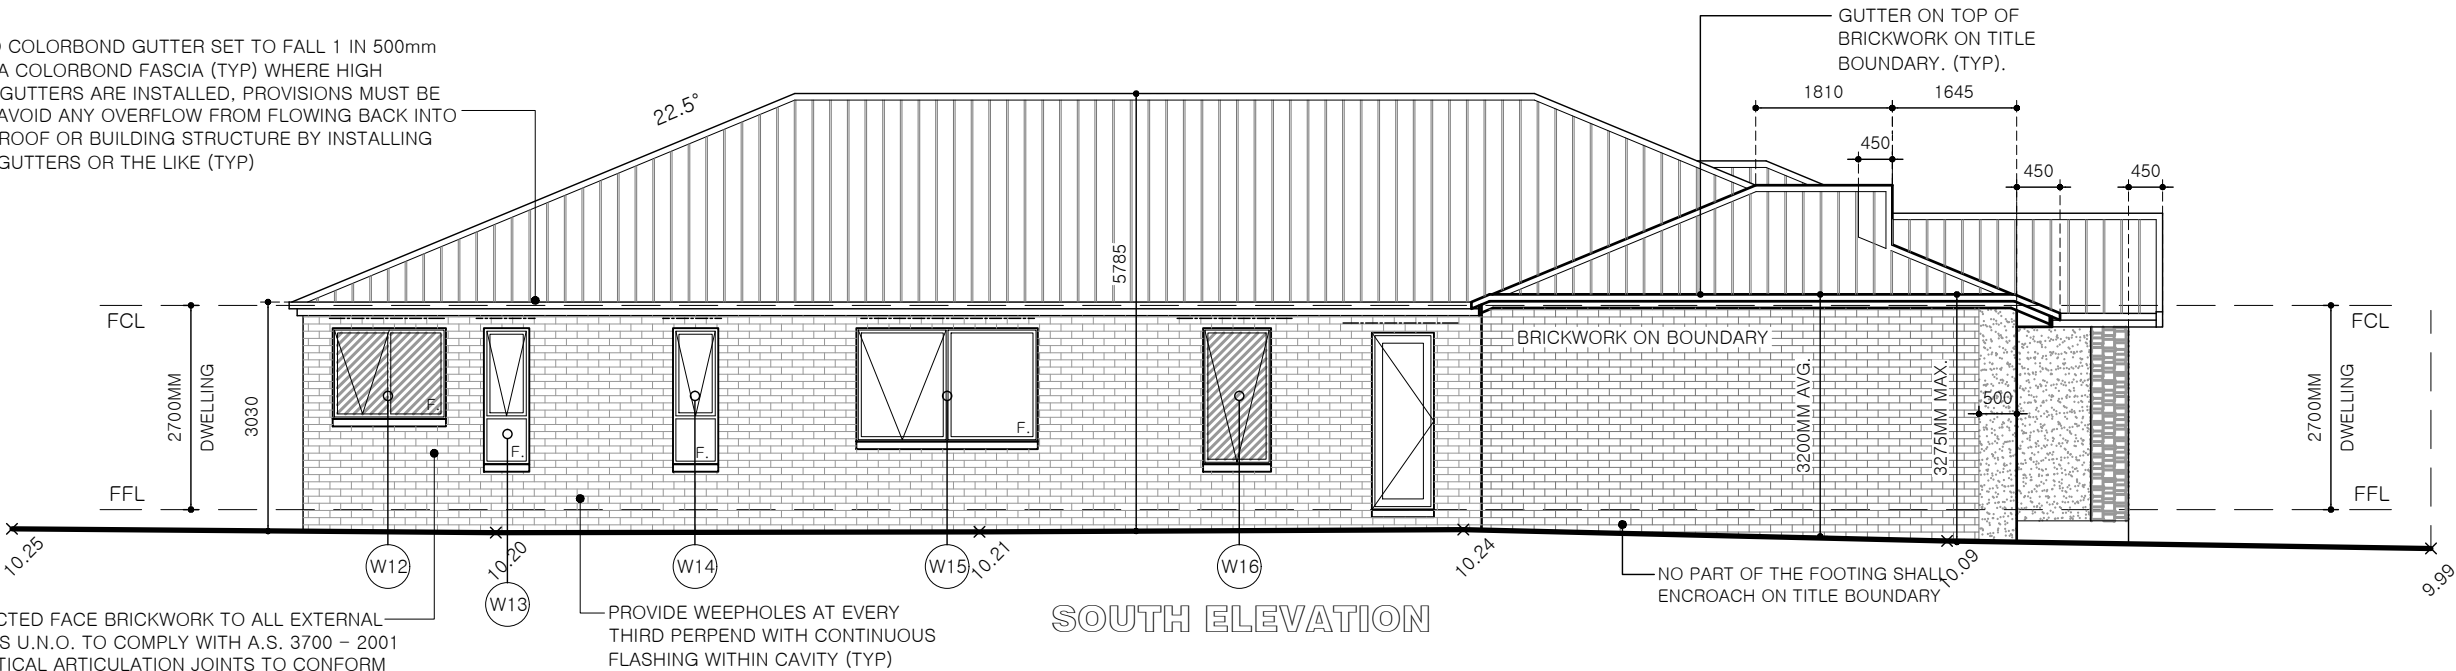

ALL ARTICULATION JOINTS ARE TO BE CONTIGUOUS ADJACENT TO OPENINGS

WEEPHOLES SHALL BE PROVIDED AT 1.2M CENTERS AND ABOVE OPENINGS GREATER THAN 1M

DAMP PROOF COURSE HEIGHTS  
i) 150MM ABOVE EXTERNAL GROUND  
ii) 75MM ABOVE EXTERNAL PAVED SURFACE

DRAWING TITLE  
ELEVATIONS

© THIS PLAN, DESIGN OR IDEAS MAY NOT BE COPIED, LOANED OR BORROWED WITHOUT PRIOR CONSENT FROM PLANFORM. THIS DOCUMENT IS CONFIDENTIAL


BUILDER  
PARVINDER SINGH BATT  
EAGLE EYE CONSTRUCTIONS  
130 HORSLEY ST THORNHILL PARK  
0413 111 596  
EAGLEEECONSTRUCTIONS80GMAIL.COM

PROJECT:  
PROPOSED DWELLING  
AT:  
5127 HOWELL CRESCENT  
TRUGANINA VIC 3029

FOR:  
KULWINDER SINGH BRAR / ARWINDER KAUR BRAR

DRAWN: JT / EY  
DATE: 5.03.25  
SCALE: 1:100 (A3)  
JOB NO: 10172025  
STATUS: WORKING DWG  
PG NO: 06

REV	DATE	AMENDMENT
—	18.02	CONCEPT

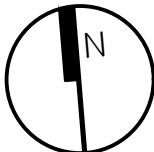


E | INFO@PLANFORM.COM.AU  
PH | 0431 020 698  
MAIL | PO BOX 576, SOUTH MORANG, VIC, 3752.  
WEB | WWW.PLANFORM.COM.AU


5B / 2 MURDOCH ROAD SOUTH MORANG  
SOUTH MORANG CORPORATE CENTRE





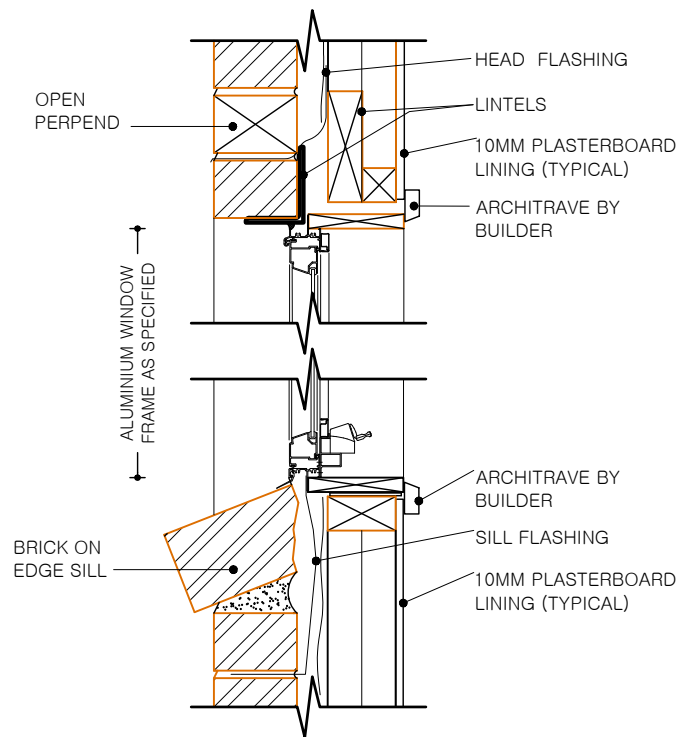

WINDOW DETAIL  
SCALE 1:20

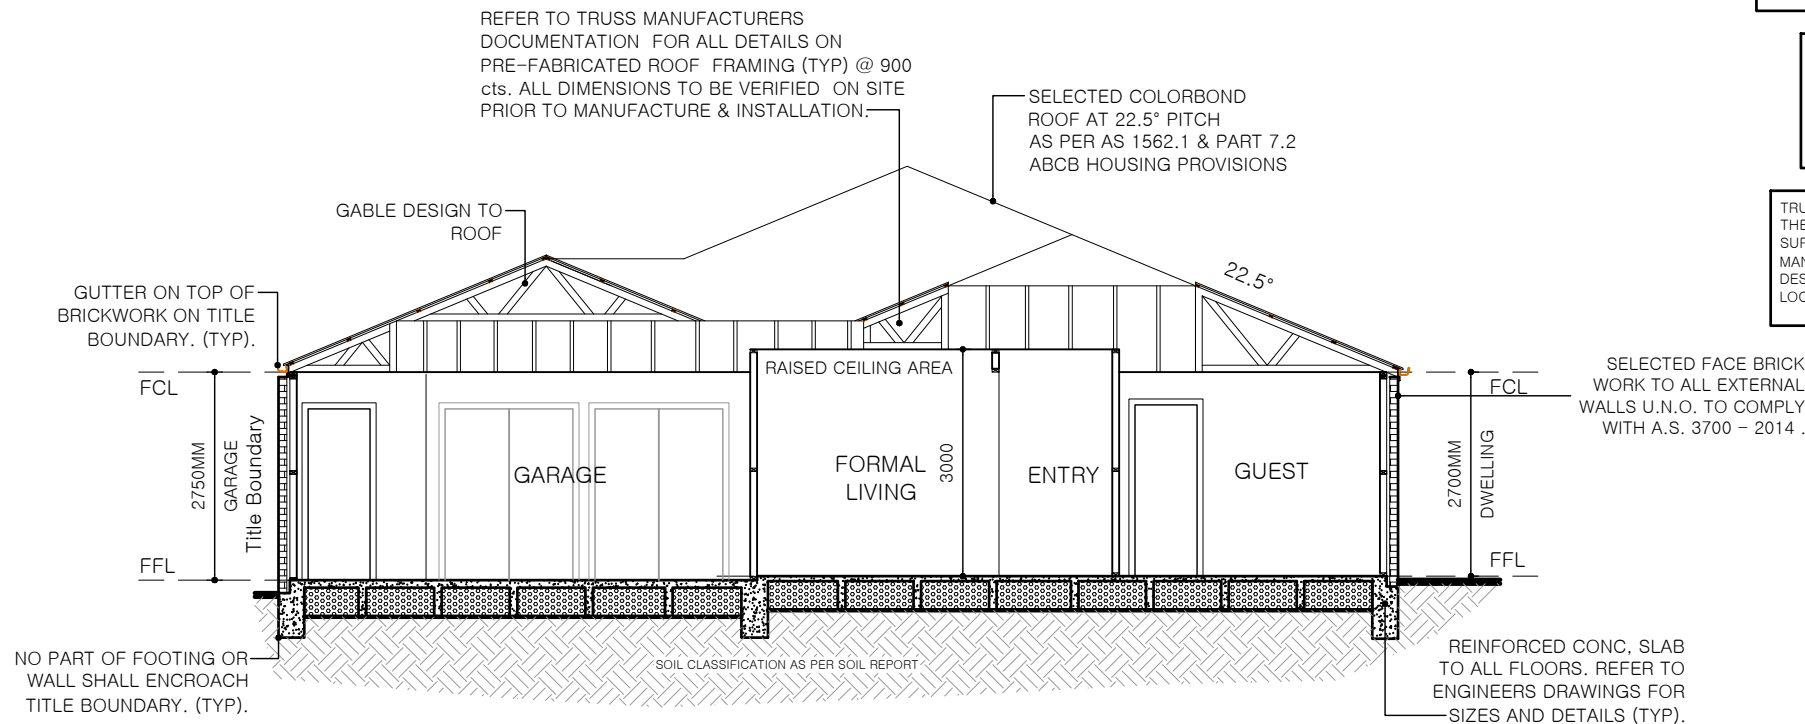

SECTION A  
SCALE 1:100


STRUCTURAL TIMBER WORK – ALL STRUCTURAL TIMBER WORK AND ASSOCIATED CONNECTIONS SHALL COMPLY WITH A.S. 1720 TIMBER STRUCTURES CODE. ALL TIMBER MEMBERS SHALL BE STRESS GRADED AND MARKED IN ACCORDANCE WITH A.S. 2858, A.S. 1748, A.S. 1749 AND B.C.A. ALL TIMBER FRAMING INCLUDING FLOORS, WALLS AND ROOF, SHALL COMPLY WITH AS 1684 TIMBER FRAMING CODE. ALL WALL BRACING SHALL BE IN ACCORDANCE WITH A.S. 1684.

PROVIDE 10mm EXPANSION JOINTS @ 5000 MAX. CRS. IN MASONRY WALLS ABOVE OR CLOSE TO JUNCTIONS BETWEEN: DIFFERENT TYPES OF FOOTING SYSTEMS, FOOTINGS FOUNDED AT SIGNIFICANTLY DIFFERENT DEPTHS, OR FOOTINGS FOUNDED ON SIGNIFICANTLY DIFFERENT MATERIALS. (ie. CLAY & ROCK) ALSO WHERE NEW BRICKWORK ABUTTS EXISTING BRICKWORK.


TRUSS MANUFACTURERS SPECIFICATIONS TO BE PROVIDED PRIOR TO THEIR ERECTION AND LOAD BEARING POINTS I.E LINTELS, STUDS SUPPORTING CONCENTRATED LOADS TO BE DESIGNED BY TRUSS MANUFACTURER AND/OR STRUCTURAL ENGINEER. IF STRUCTURAL DESIGN WAS PROVIDED THE DESIGN ENGINEER TO VERIFY TRUSS LOCATIONS AND DESIGN FOR LOAD BEARING POINTS AS REQUIRED.

SELECTED FACE BRICK WORK TO ALL EXTERNAL WALLS U.N.O. TO COMPLY WITH A.S. 3700 – 2014 .

REINFORCED CONC. SLAB TO ALL FLOORS. REFER TO ENGINEERS DRAWINGS FOR SIZES AND DETAILS (TYP).

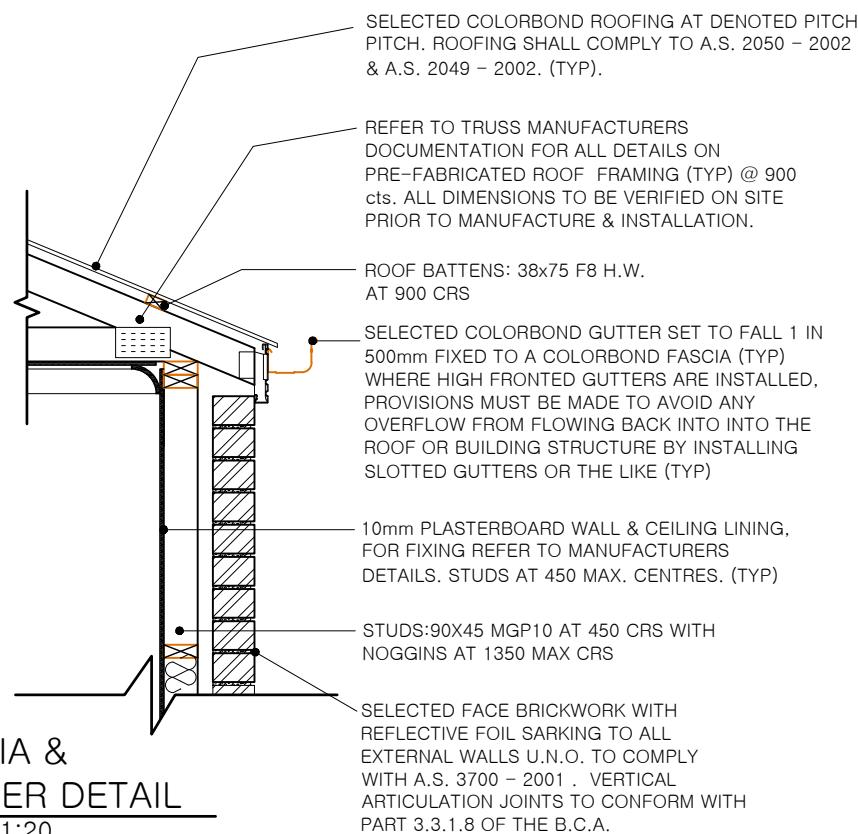


FASCIA & GUTTER DETAIL  
SCALE 1:20

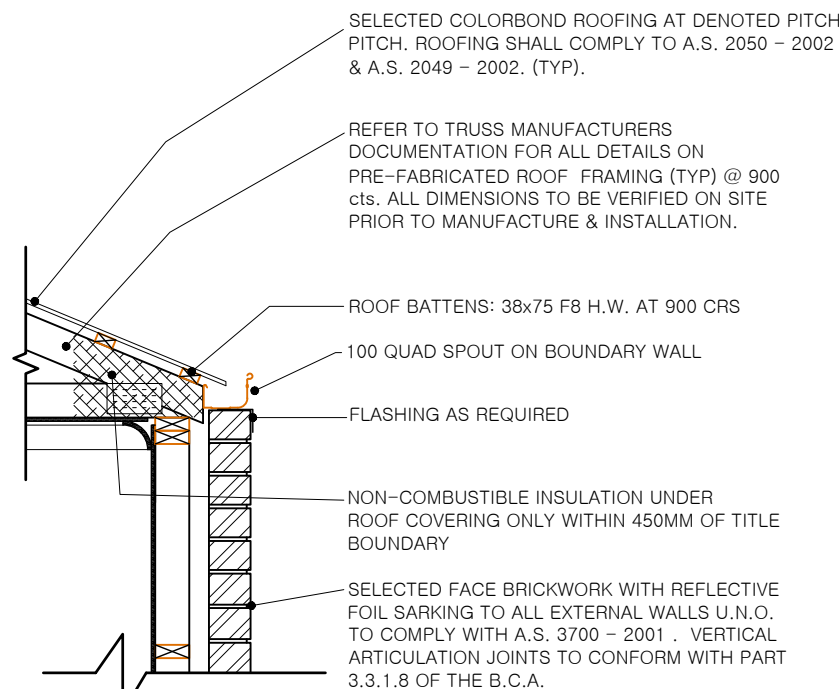


GUTTER ON BRICKWORK DETAIL  
SCALE 1:20


REFER TO TRUSS MANUFACTURERS DOCUMENTATION FOR ALL DETAILS ON PRE-FABRICATED ROOF FRAMING (TYP) @ 600 cts. ALL DIMENSIONS TO BE VERIFIED ON SITE PRIOR TO MANUFACTURE & INSTALLATION.

SELECTED COLORBOND ROOFING AT DENOTED PITCH. ROOFING SHALL COMPLY TO A.S. 2050 – 2002 & A.S. 2049 – 2002. (TYP).

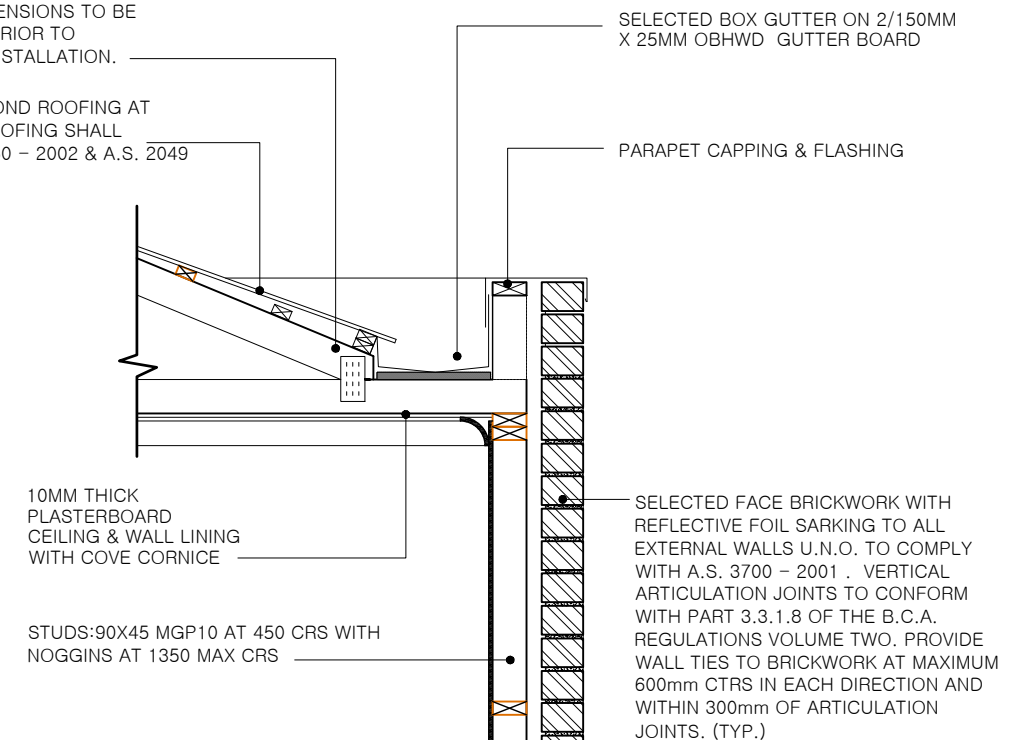


BOX GUTTER DETAIL-BRICK  
SCALE 1:20

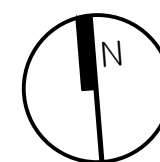


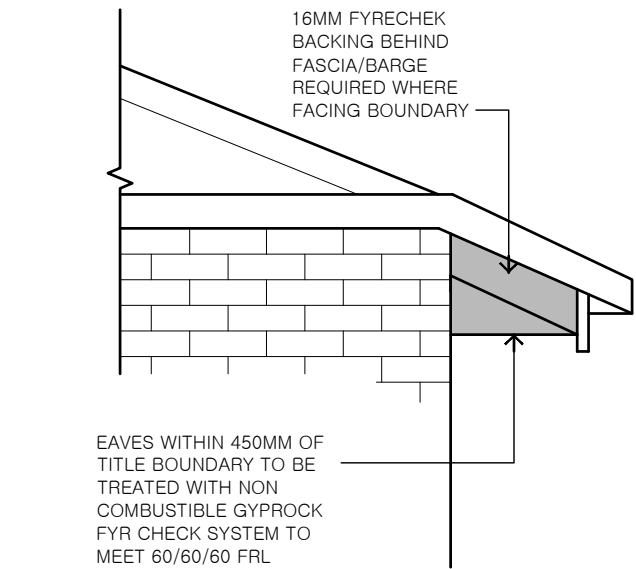


FIRE RATED EAVE  
NTS

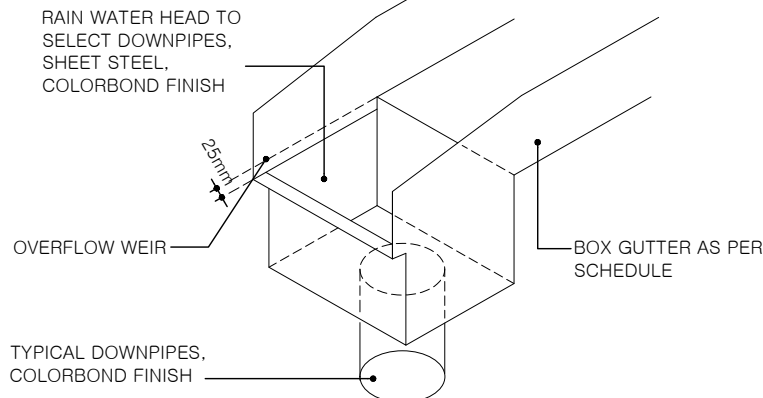


RAIN WATER HEAD DETAIL  
SCALE 1:10

ALL RAINWATER HEADS TO COMPLY WITH FIGURE 5.3.1 (A) OF HB39

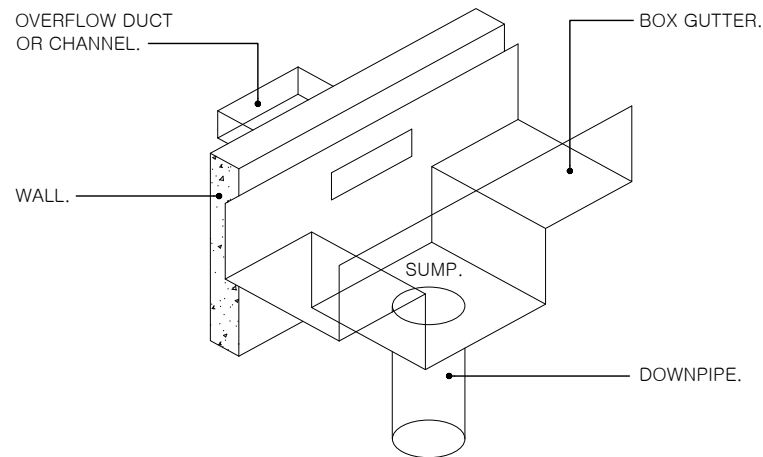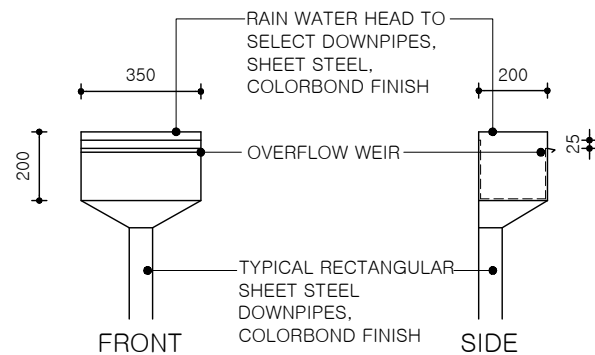

SUMP DETAIL  
NOT TO SCALE

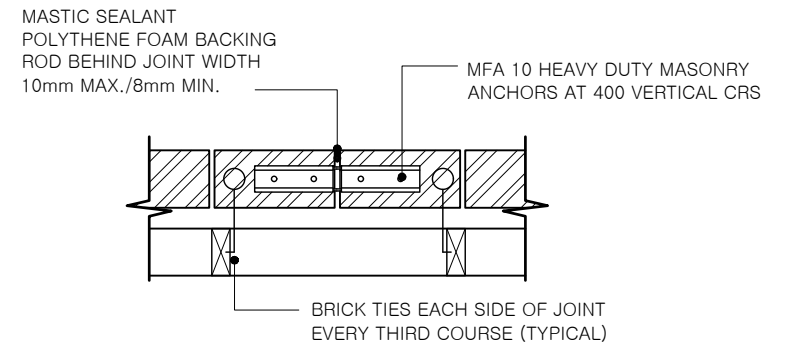


PROVIDE FULL HEIGHT ARTICULATION JOINTS TO BRICKWORK AT 500mm max CTRS OR AS STATED ON GEOTECHNICAL & SITE INVESTIGATION REPORT.

BRICK ARTICULATION JOINT DETAIL  
NOT TO SCALE


RAIN WATER HEAD DETAIL  
SCALE 1:10

NOTES:  
1. SUB SILL IS INSTALLED BEFORE DOOR.  
2. SEAL BETWEEN SILL, PACKER AND MEMBRANE BEFORE DRILLING FIXING HOLES.

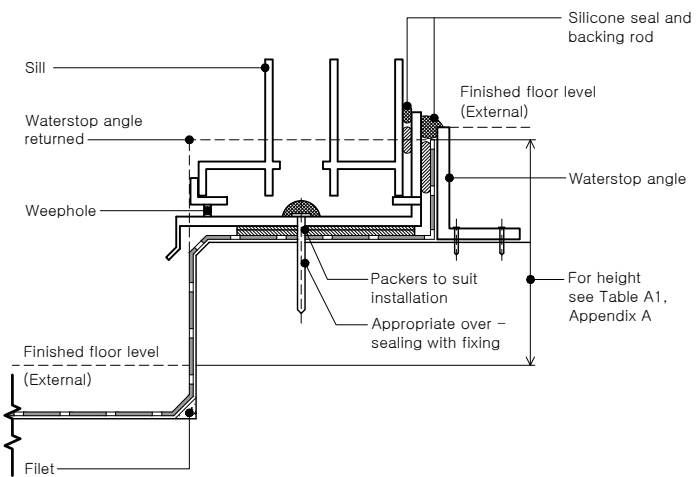


EXTERNAL WATERPROOFING DETAIL  
NOT TO SCALE

NOTES:  
1. NO SUB - SILL INSTALLED.  
2. SEAL BETWEEN SILL/PACKER AND MEMBRANE BEFORE DRILLING FIXING HOLES.

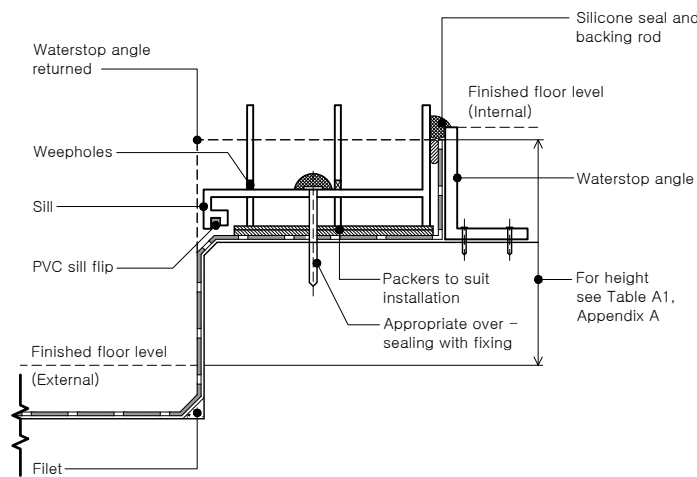

EXTERNAL WATERPROOFING DETAIL  
NOT TO SCALE

- A WATERSTOP SHALL BE POSITIONED SO THAT ITS VERTICAL LEG WILL FINISH A MINIMUM OF 5MM ABOVE THE FINISHED FLOOR LEVEL, WHERE A SHOWER SCREEN IS TO BE INSTALLED.  
- WHERE THE WATER STOP INTERSECTS WITH A WALL OR IS JOINED, THE JUNCTION SHALL BE WATERPROOF.

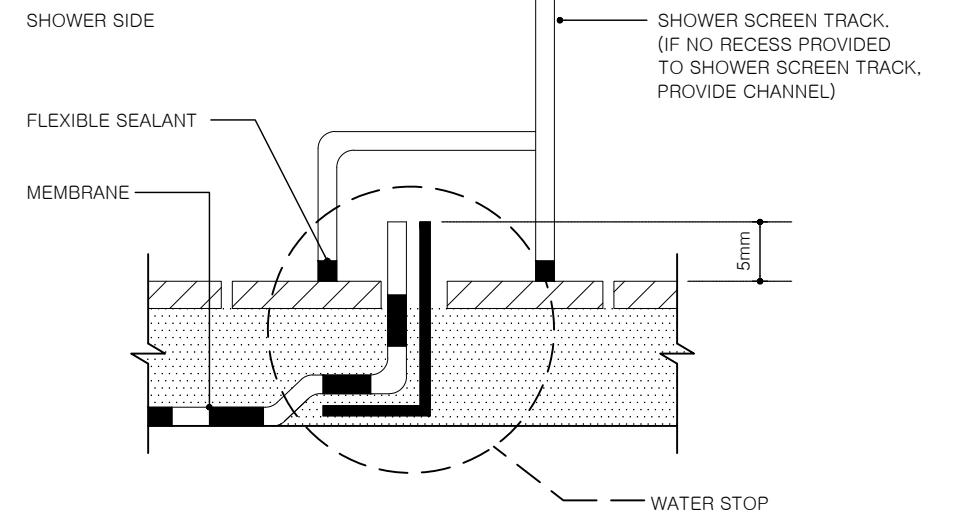

WATER STOP DERAIL FOR ENCLOSED SHOWER WITH NO STEP DOWN  
NOT TO SCALE



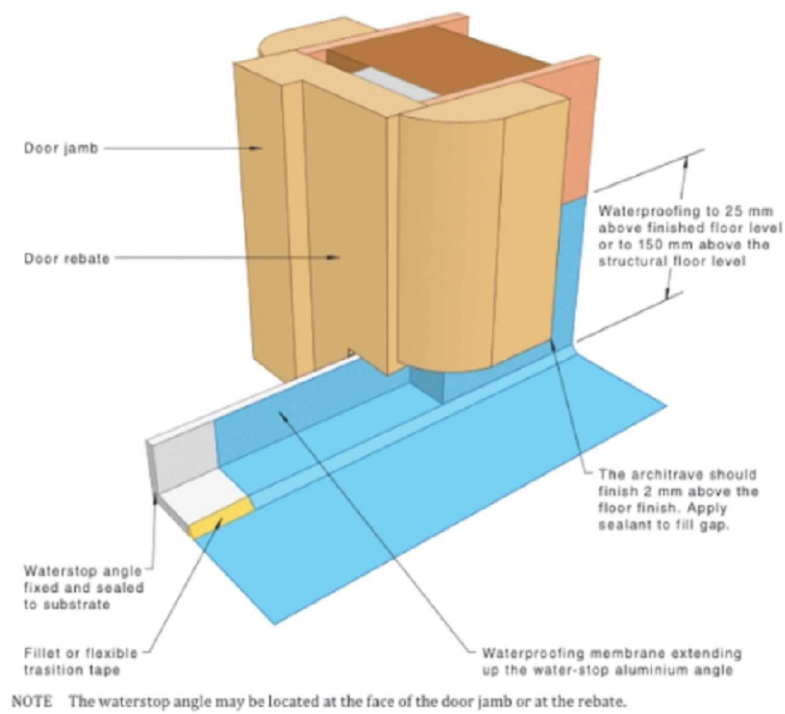


Figure 4.9.1(A) — Example of liquid waterproofing at door opening framework


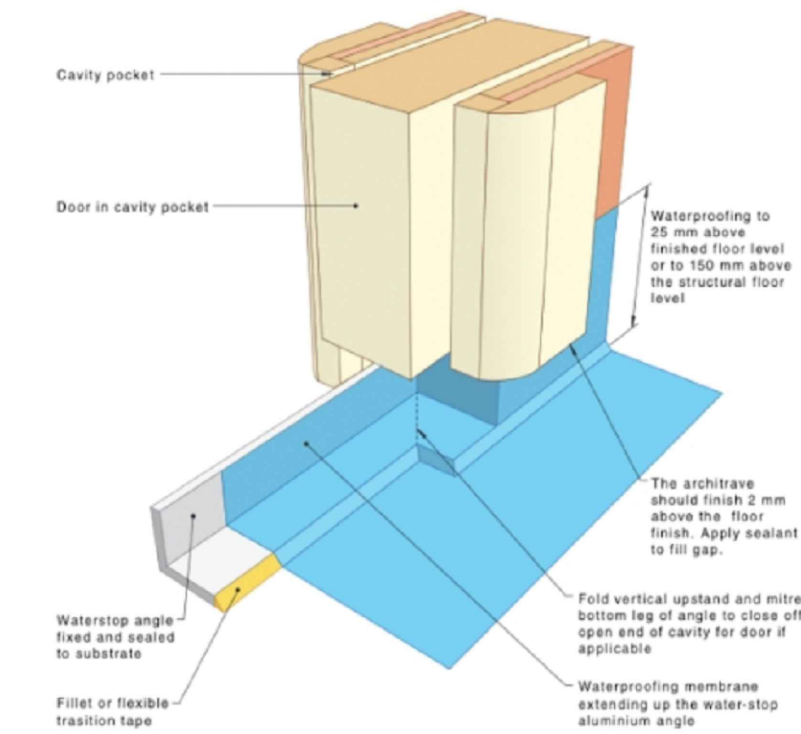


Figure 4.9.1(B) — Waterproofing at door opening cavity slider


## PERIMETER FLASHING DEATIL

NOT TO SCALE

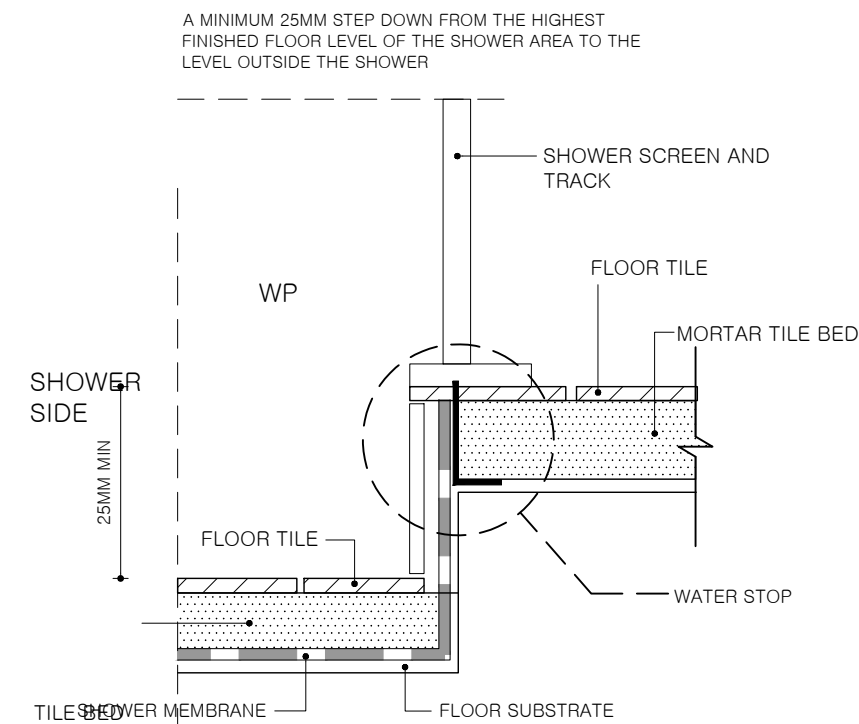

## ENCLOSED AND UNENCLOSED STEPDOWN SHOWERS


NOT TO SCALE

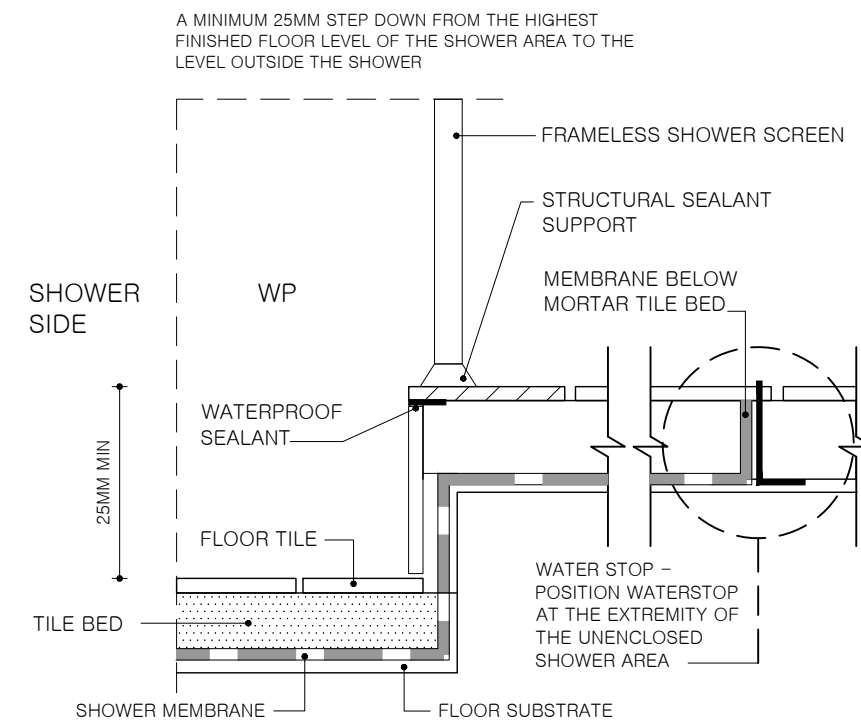

WATERPROOF AS PER AS 3740  
AND NCC 2022 PART 10.2


## SHOWER WATERPROOFING DETAIL


NOT TO SCALE

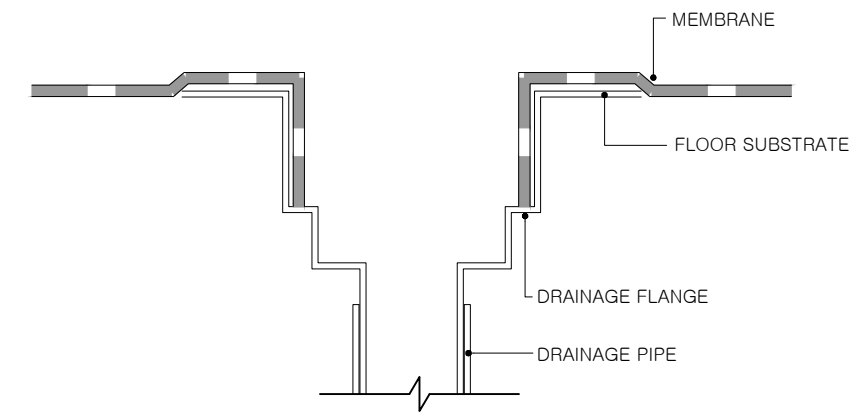



## FLOOR WASTE – TYPICAL MEMBRANE TERMINATION AT DRAINAGE OUTLET

NOT TO SCALE




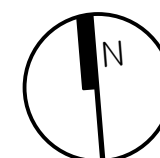


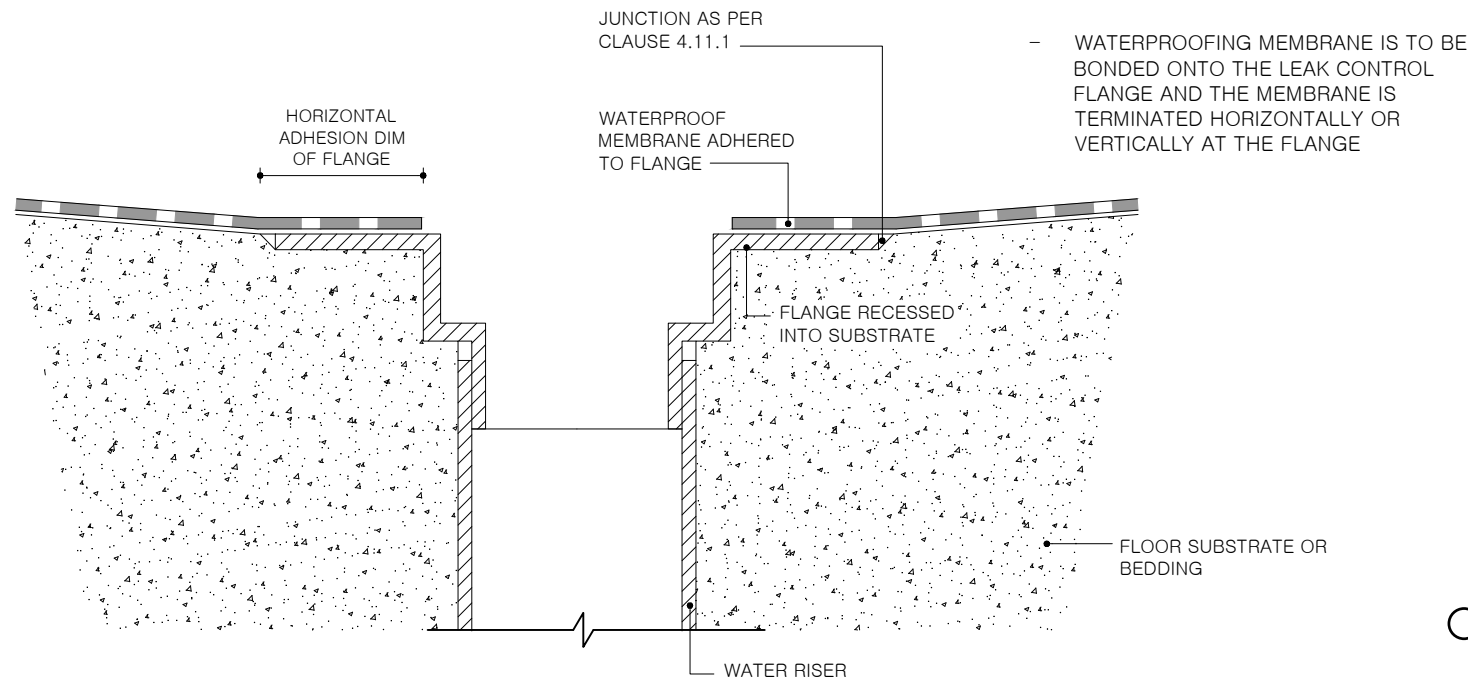


BOND BREAKER DETAIL  
NOT TO SCALE


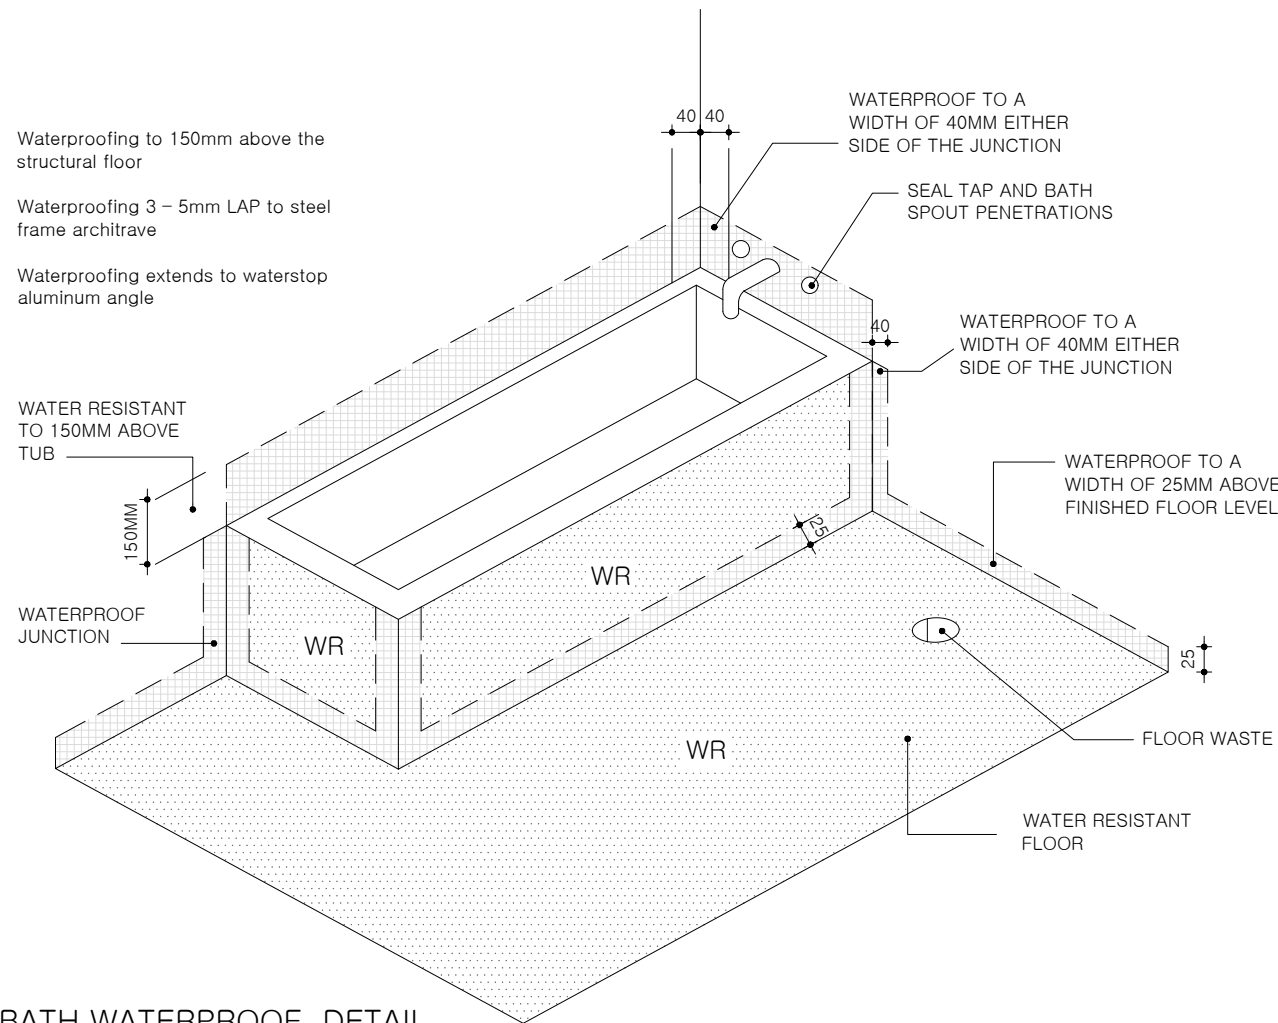
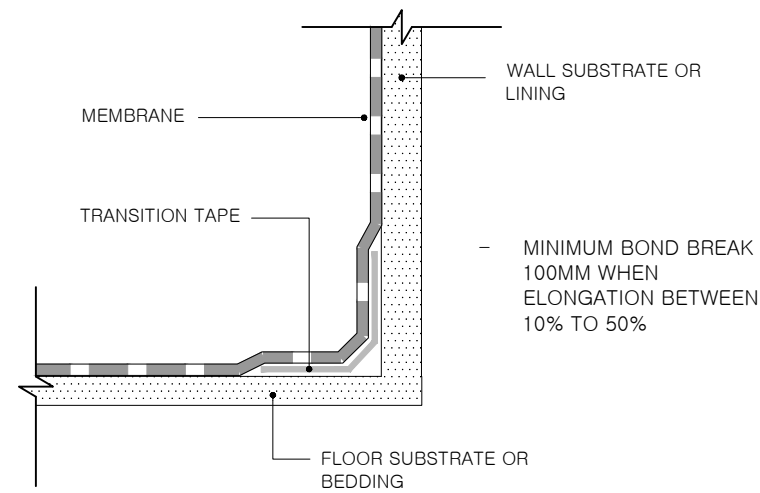


A JUNCTION WHERE WATERPROOFING TO WATERPROOFING SURFACES MEET, THE WATERPROOFING IS TO BE CONTINUOUS ACROSS THE JUNCTION AND INCORPORATE AN APPROPRIATE BOND BREAKER. WHERE THE PERIMETER FLASHING TO WALL/FLOOR SURFACES THEY SHOULD BE CONTINUOUSLY SEALED (USUALLY WITH BOND BREAKER), HAVING THE VERTICAL LEG A MINIMUM OF 25MM ABOVE THE FINISHED FLOOR LEVEL (EXCEPT DOORWAYS) AND HORIZONTAL LEG A MINIMUM WIDTH OF 50MM. A WATER STOP WITH A VERTICAL LEG FINISHING FLUSH WITH THE FINISHED FLOOR LEVEL IS TO BE INSTALLED AT FLOOR LEVEL OPENINGS. PROTECTING WATER MIGRATING TO NON-WET AREAS.

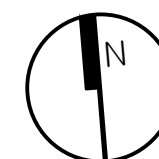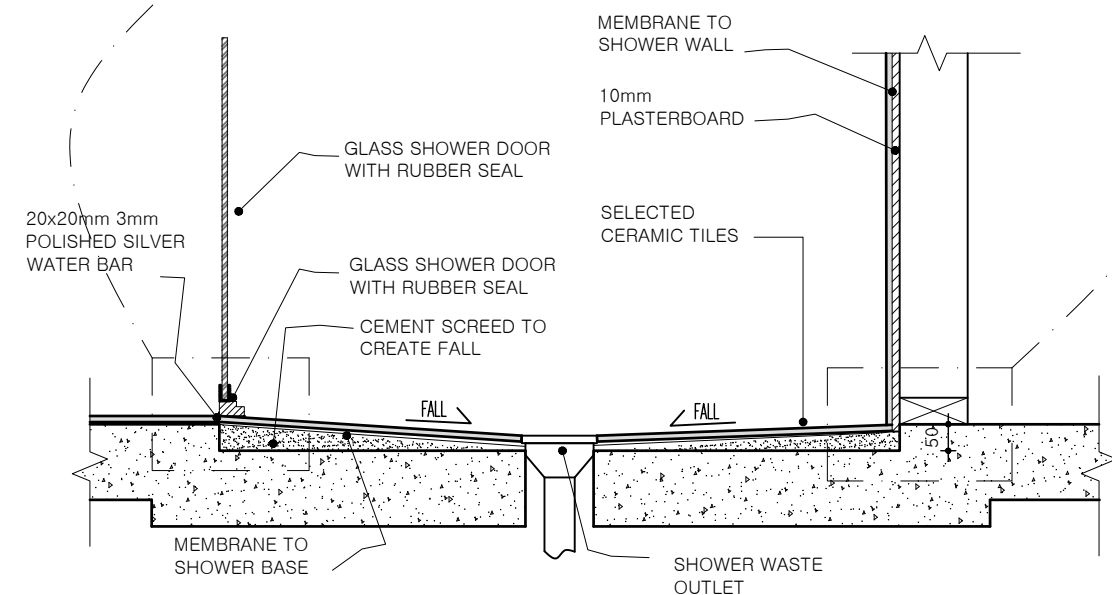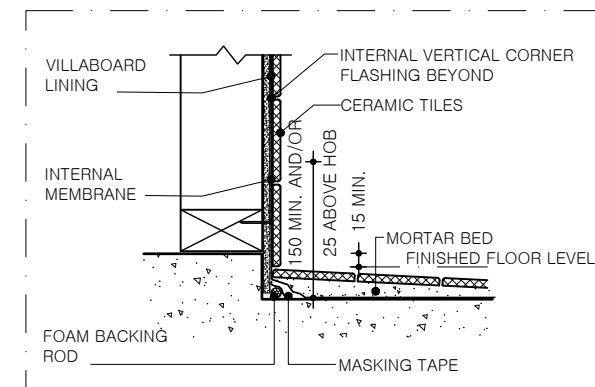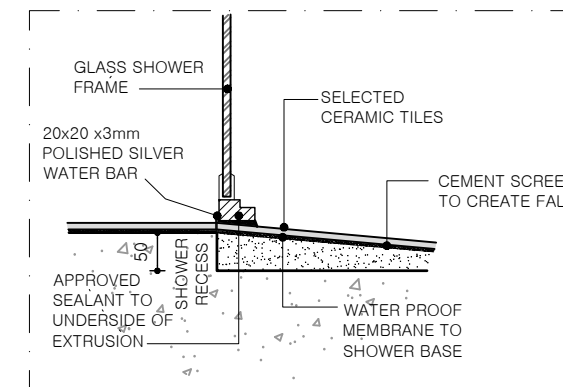

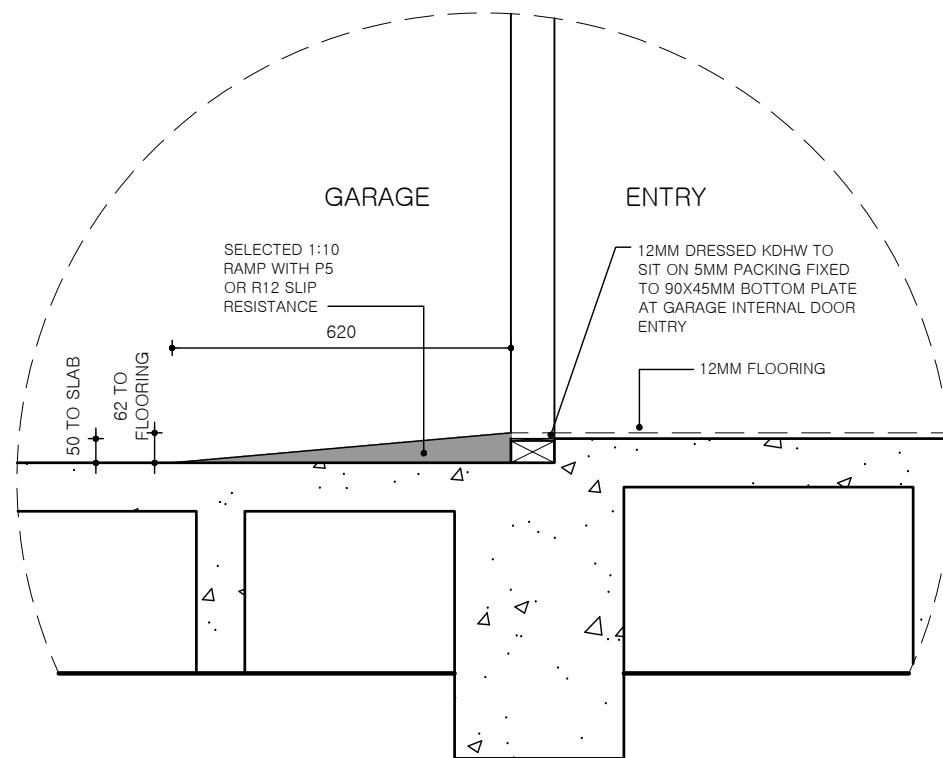


○ GARAGE STEP FREE RAMP DETAIL

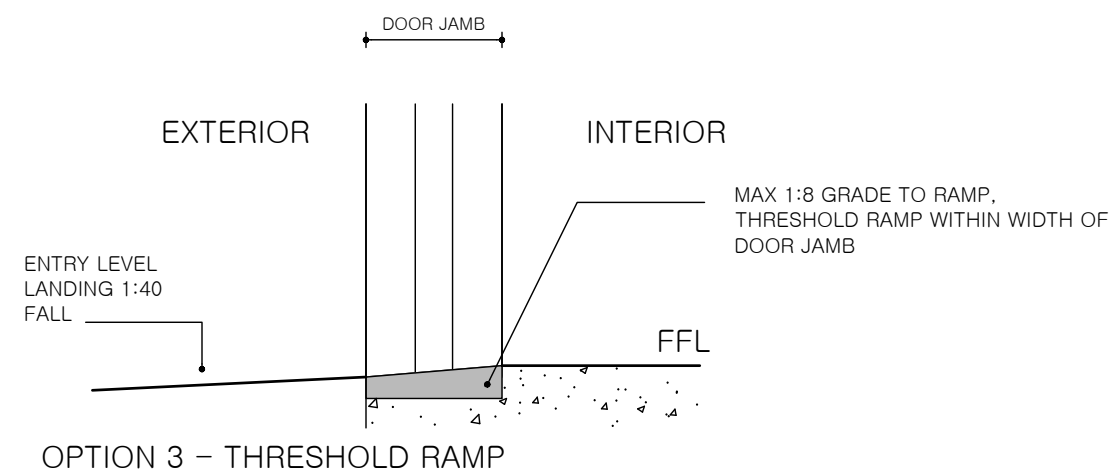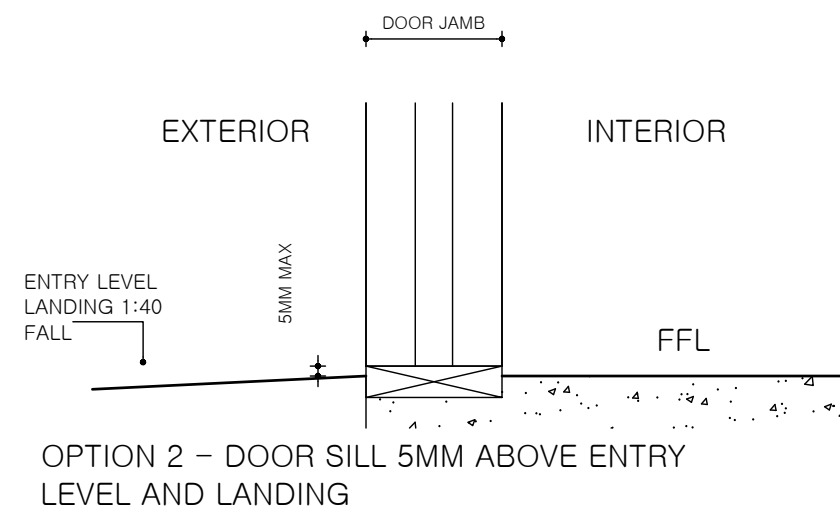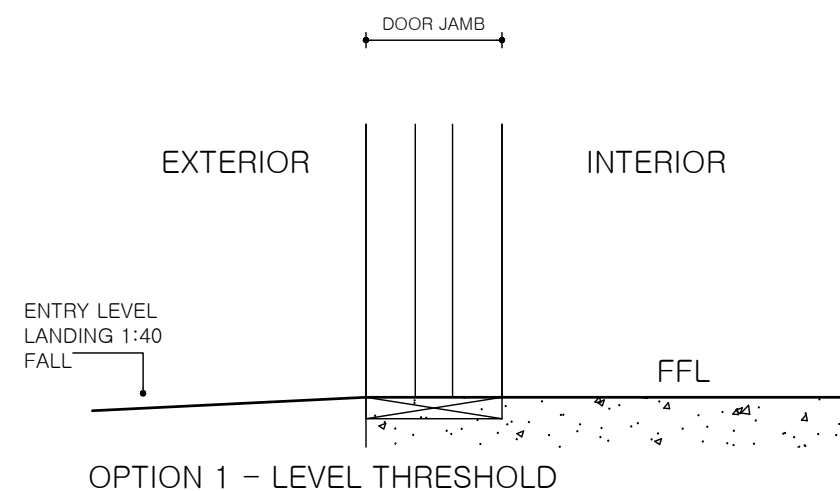


## THRESHOLD RAMP DETAILS

**Figure 2.1: Measurement of clear opening width**

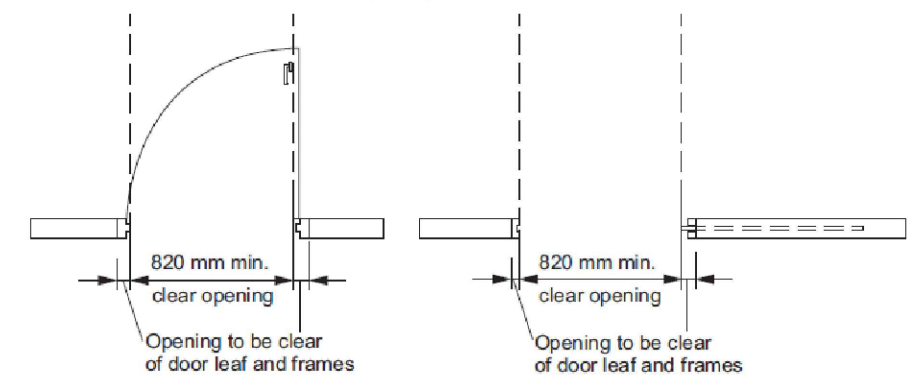


## DOOR OPENING DETAIL

Figure 4.2: Circulation space for a toilet pan

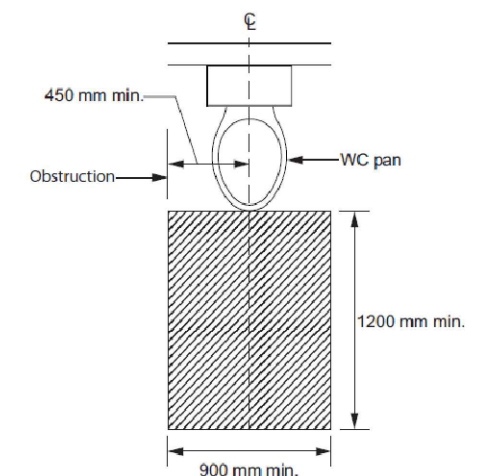

## SANITARY COMPARTMENT CIRCULATION SPACE

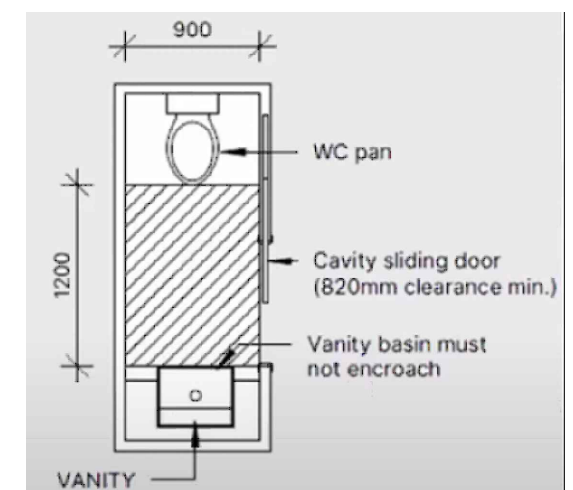

DRAWING TITLE  
DETAILS


© THIS PLAN, DESIGN OR IDEAS MAY NOT BE COPIED, LOANED  
OR BORROWED WITHOUT PRIOR CONSENT FROM PLANFORM.  
THIS DOCUMENT IS CONFIDENTIAL

**BUILDER**  
PARVINDER SINGH BATTI  
EAGLE EYE CONSTRUCTION  
130 HORSLEY ST THORNHILL PARK  
0413 111 596  
EAGLEEYECONSTRUCTIONS8@GMAIL.COM

PROJECT:  
PROPOSED DWELLING  
AT:  
5127 HOWELL CRESCENT  
TRUGANINA VIC 3029  
FOR:  
M KULWINDER SINGH BRAR / ARWINDER KAUR BRAR

DRAWN: JT / EY  
DATE: 5.03.25  
SCALE: 1:100 (A3)  
JOB NO: 10172025  
STATUS: WORKING DWG  
PG NO: 11

REV	DATE	AMENDMENT
—	18.02	CONCEPT

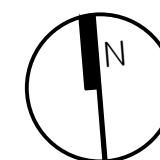

E | INFO@PLANFORM.COM.AU  
PH | 0431 020 698  
MAIL | PO BOX 576, SOUTH MORANG, VIC, 3752.  
WEB | WWW.PLANFORM.COM.AU

5B / 2 MURDOCH ROAD SOUTH MORANG  
SOUTH MORANG CORPORATE CENTRE





Figure 6.2a: Location of noggings for walls surrounding a bath

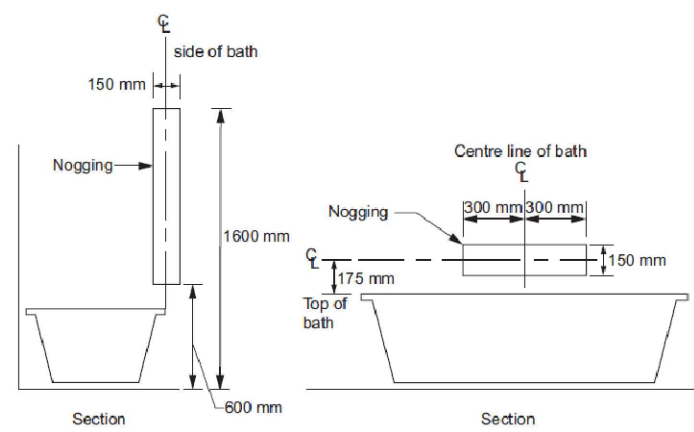


Figure 6.2b: Location of sheeting for walls surrounding a bath

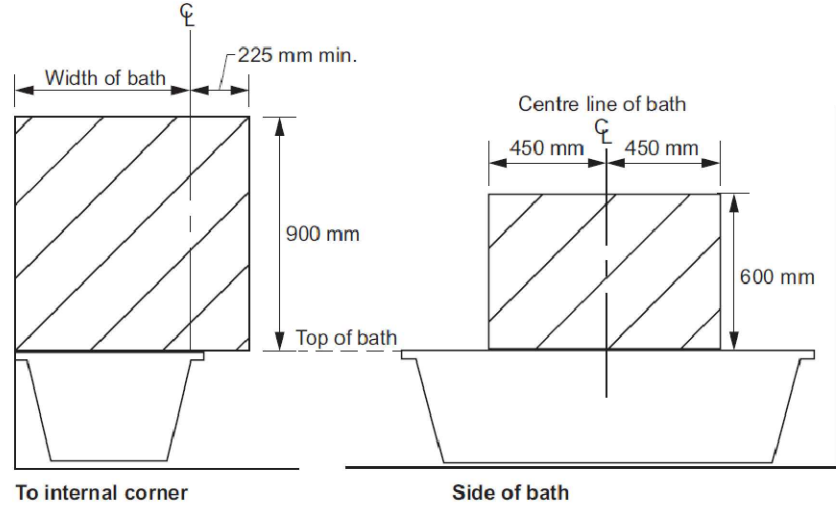


Figure 6.2c: Location of noggings for shower walls

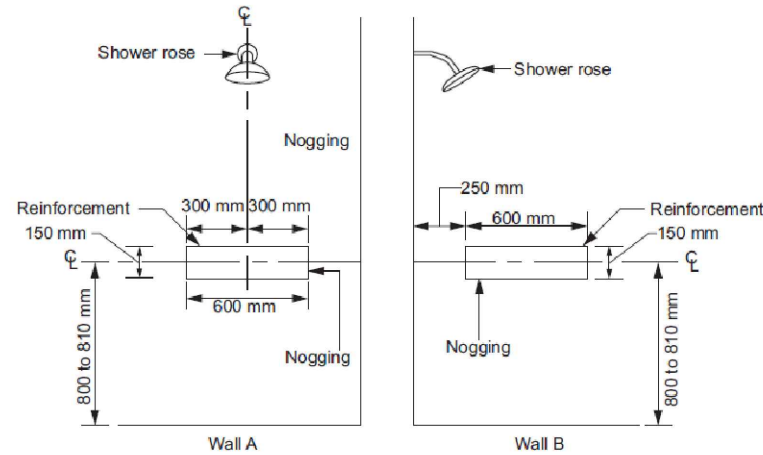


Figure 6.2d: Location of sheeting for shower walls

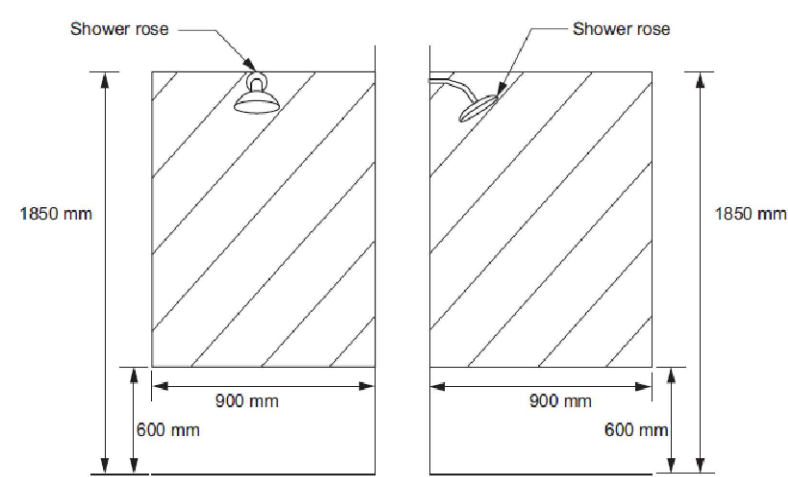


Figure 6.2e: Minimum extent of sheeting for wall adjacent to a toilet pan  
Minimum extent of structural sheeting clear of any door frame, window frame or wall opening

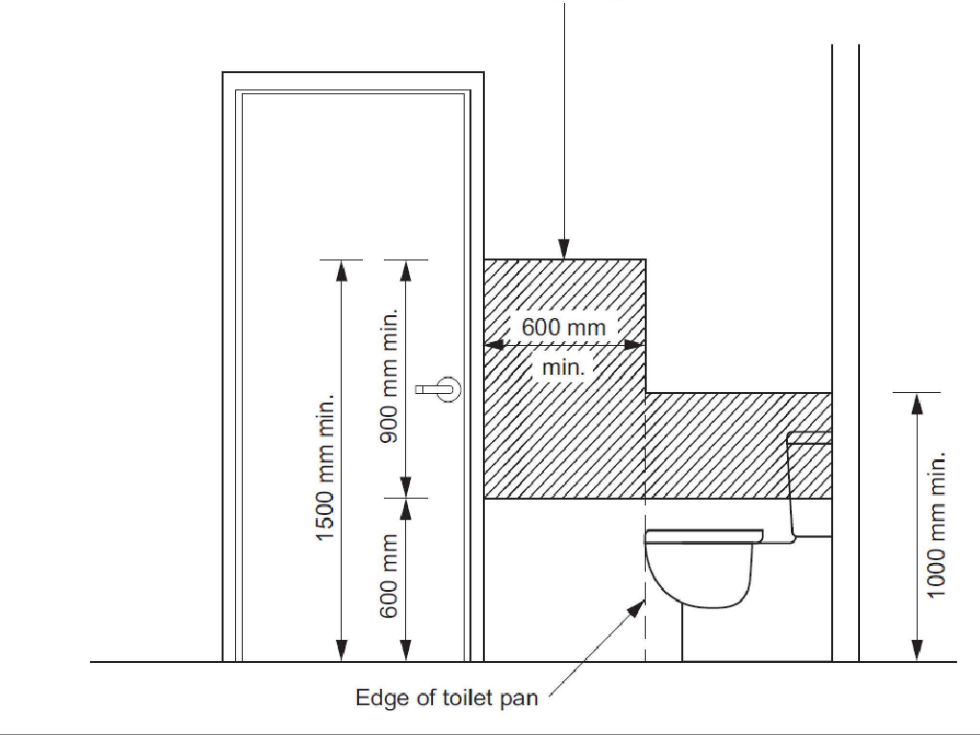


Figure 6.2f: Location of noggings for a wall behind a toilet pan


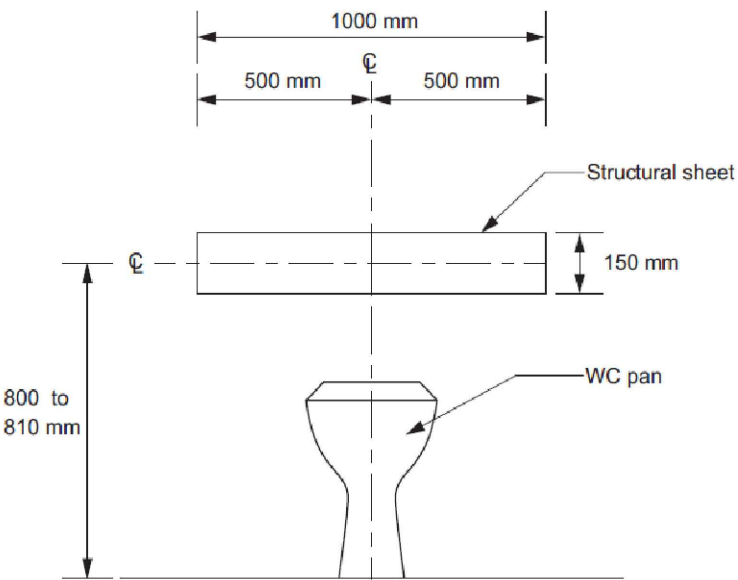


Figure 6.2g: Location of sheeting for a wall behind a toilet pan

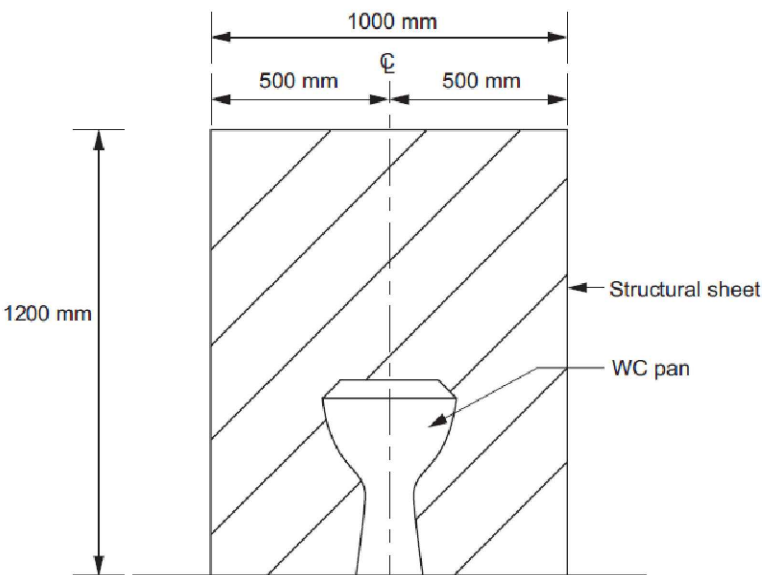

POWER LEGEND			
	SINGLE GPO – 300mm		DOUBLE GPO – 300mm
	SINGLE GPO – 1100mm		DOUBLE GPO – 1100mm
	SINGLE GPO – 1350mm		TELEVISION POINT
	WEATHERPROOF GPO – EXTERNAL		DATA POINT
	SINGLE GPO – D/WASHER @ 300H		SMOKE DETECTOR
	SINGLE GPO – FOR M/WAVE @ 750H		METER BOX
	SINGLE GPO – FOR SECURITY SYS.		TELEPHONE POINT

LIGHTING LEGEND			
	40w CEILING LIGHT & BATTEN HOLDER		JUNCTION BOX
	8w LED DOWNLIGHT		CEILING FAN
	OYSTER LIGHT		CEILING FAN WITH LIGHT
	EXTERNAL LIGHT POINT		PARA FLOOD LIGHT – SINGLE
	HEATER/FAN & LIGHT – 2 GLOBE		PARA FLOOD LIGHT – DOUBLE
	HEATER/FAN & LIGHT – 4 GLOBE		EXTERNAL SENSOR LIGHT
	PENDENT LIGHT		600 FLUORO – SINGLE
			600 FLUORO – DOUBLE

	1200 FLUORO – SINGLE
	1200 FLUORO – DOUBLE
	WALL LIGHT BATTEN HOLDER
	DIMMER LIGHT SWITCH
	LIGHT TIMER
	CEILING EXHAUST FAN
	LIGHT SWITCH LOCATION (approx)

HEATING LEGEND	
	CEILING HEATING DUCT (APPROX LOCATION)
	HEATING UNIT WITH LIGHT & GPO IN CEILING
	THERMOSTAT
	RETURN AIR
	CEILING COOLING DUCT (APPROX LOCATION)

DUCTED VACUUM	
	DUCTED VACUUM UNIT
	DUCTED VACUUM POINT (APPROX)

INTERCOM	
	COLOR INTERCOM MONITOR
	DOOR BELL POINT LINKED WITH INTERCOM

SA DENOTES LOCATIONS OF SMOKE ALARMS TO BE PROVIDED AND INSTALLED IN ACCORDANCE WITH A.S. 3786-1993 & UNLESS INSTALLED IN AN EXISTING PART OF A CLASS 1, 2 OR 3 BUILDING OR A CLASS 4 PART OF A BUILDING, THE SMOKE ALARM SHALL BE HARD WIRED WITH BATTERY BACKUP.

EF DENOTES: CEILING EXHAUST FAN PROVIDE A LIGHT AND AN EXHAUST FAN WHERE NATURAL LIGHTING AND VENTILATION IS NOT PROVIDED WHERE REQUIRED BY LOCAL AUTHORITY, DUCT THE EXHAUST TO THE OUTSIDE.

ELECTRICAL NOTE  
ALL SYMBOLS AND SYMBOL LOCATIONS ARE INDICATIVE ONLY AND TO BE USED AS A GUIDE ONLY.  
SYMBOLS AND LOCATIONS ARE NOT DRAWN TO SCALE.

- NOTES: PROVIDE LIGHT & POWER FOR HEATER UNIT WITHIN ROOF SPACE NEAR ROOF ACCESS. PROVIDE POWER POINT WITHIN ROOF SPACE FOR COOLING UNIT. ALL EXTERNAL FITTINGS TO BE WATERPROOF

ELECTRICAL ANALYSIS TABLE					
	AREA	WATTS PER LIGHT POINT	NO. LIGHTS USED	TOTAL WATTS USED	TOTAL WATTAGE PER SQM
GROUND FLOOR	247.94	8 & 40	0	648	2.61
GARAGE	41.19	40	2	80	1.94
PORCH	7.15	8	1	8	1.12
LIGHTING NOT TO EXCEED 5 WATTS PER SQUARE METER FOR LIVING AREAS IN ACCORDANCE WITH NCC 2022.					
LIGHTING NOT TO EXCEED 3 WATTS PER SQUARE METER FOR GARAGE IN ACCORDANCE WITH NCC 2022.					

